


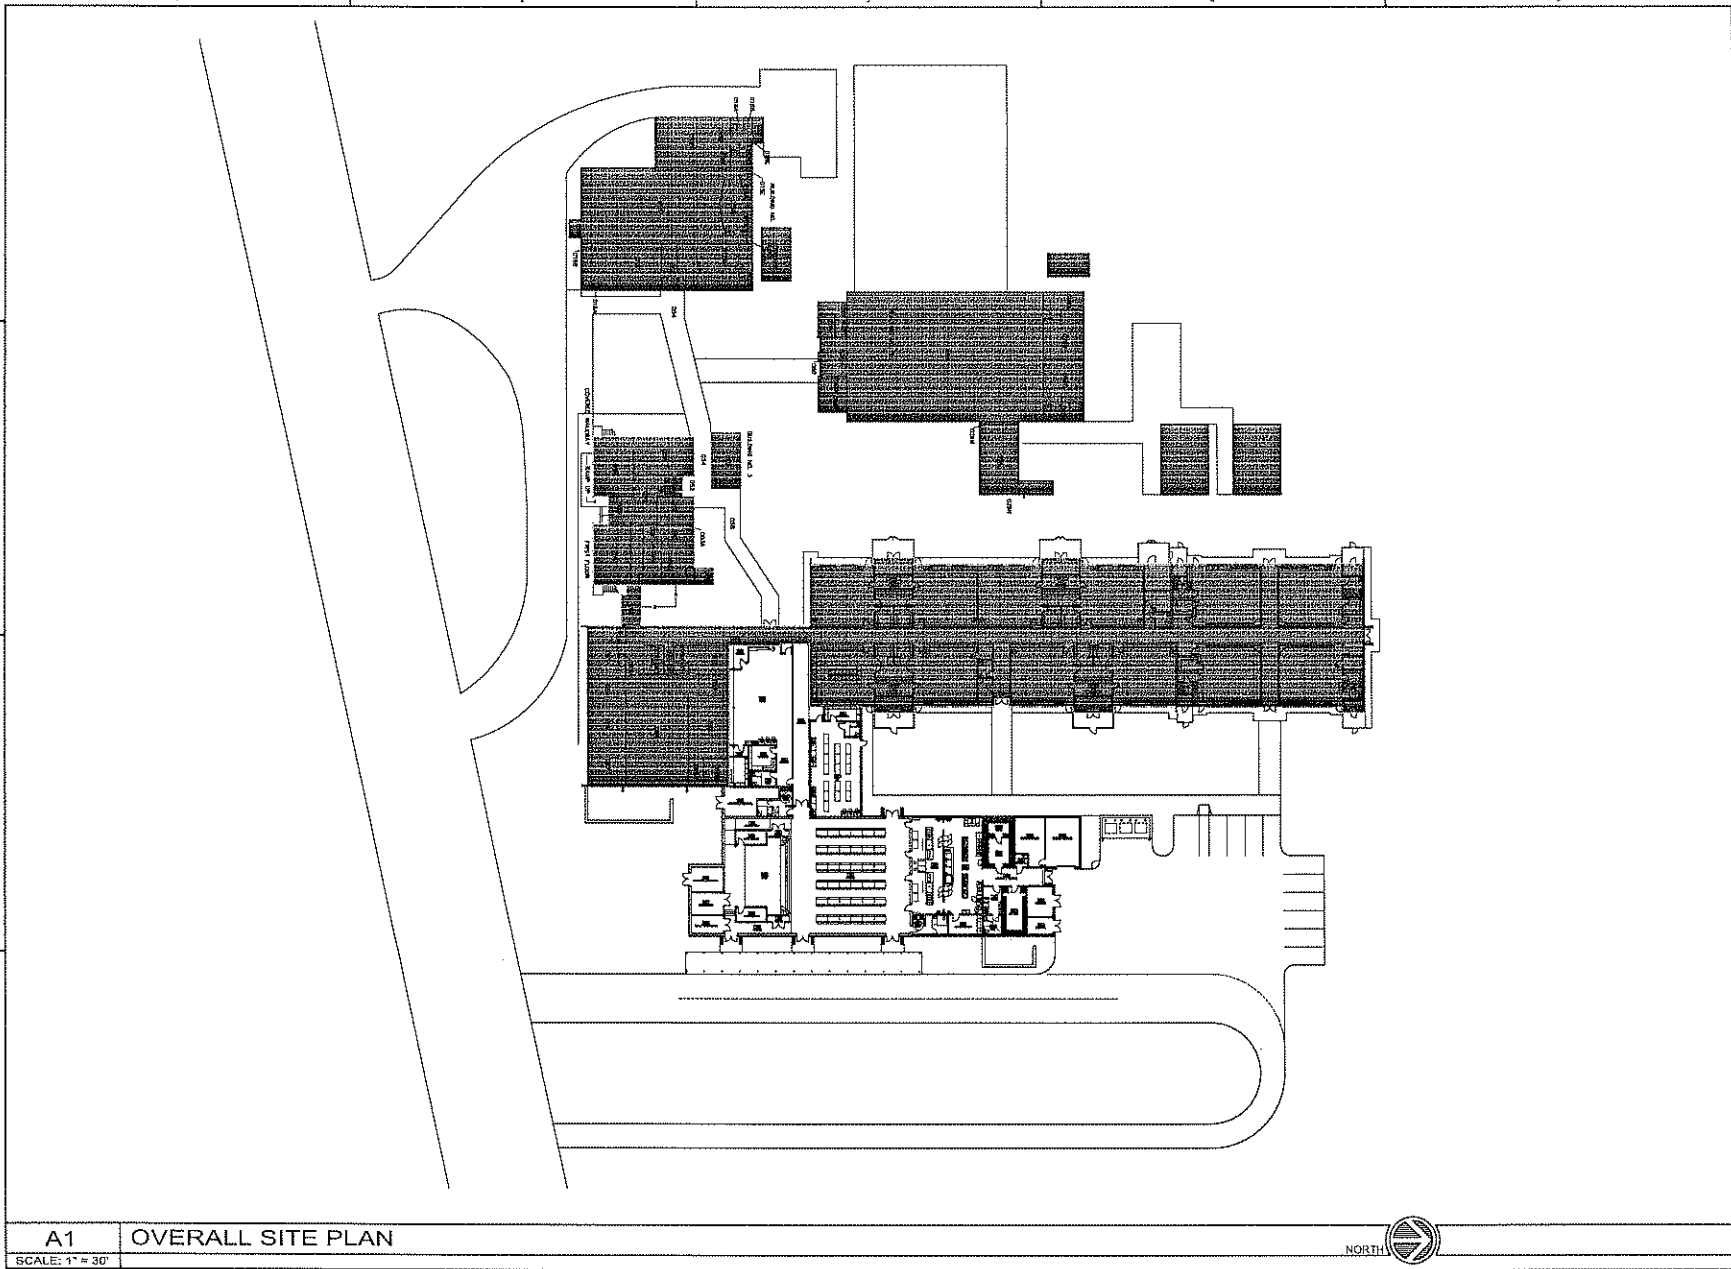



DAY AND NIGHT, INC.
40 S. PALM AVENUE, SUITE 201
DENVER, CO 80202
TELEPHONE: (303) 733-1111 FAX: (303) 733-1111
E-MAIL: info@dag.com

CONSTRUCTION DOCUMENTS
(PHASE II)

Chumuckla Elementary Kitchen & Cafeteria Addition

Revision	
NO.	DESCRIPTION
1	
2	
3	
4	
5	
6	
7	
8	
9	
10	

Drawn By: WSB
Checked By: OEG

Date: 11-27-12

Project No.: 12034

Drawing Title:
SITE PLAN

Drawing No.: A100



A1 REFLECTED CEILING PLAN
SCALE: N/A

DAVID AND GILBERT, INC.
415 PALM BLVD. SUITE 200
PENSACOLA, FL 32507
TELEPHONE: 904-242-9863 FAX: 904-242-9871
AIA #160311

THIS DRAWING IS THE PROPERTY OF THE FIRM. IT IS TO BE USED ONLY FOR THE PROJECT AND SITE SPECIFICALLY IDENTIFIED HEREON. NO PART OF THIS DRAWING IS TO BE REPRODUCED OR TRANSMITTED IN ANY FORM OR BY ANY MEANS, ELECTRONIC OR MECHANICAL, INCLUDING PHOTOCOPYING, RECORDING, OR BY ANY INFORMATION STORAGE AND RETRIEVAL SYSTEM, WITHOUT THE WRITTEN PERMISSION OF THE FIRM.

**CONSTRUCTION
DOCUMENTS
(PHASE II)**

Chumuckla Elementary
Kitchen & Cafeteria Addition

Revision

NO.	DESCRIPTION

Drawn By: OEG
Checked By: OEG


Date: 11-27-12

Project No.: 12034

Drawing Title:
REFLECTED CEILING PLAN

Drawing No.:

A101.2

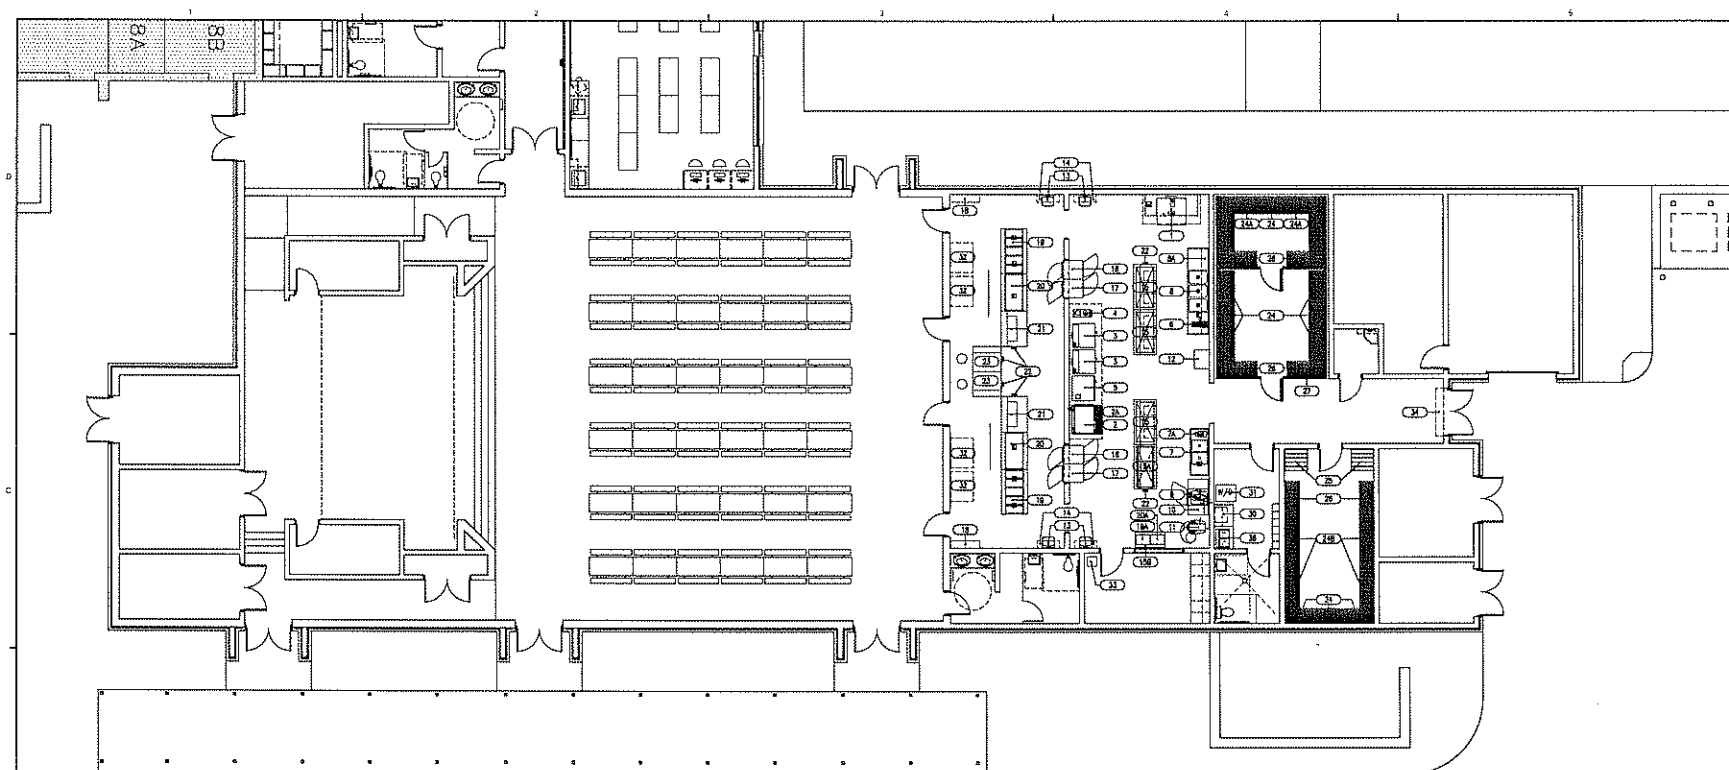

B1 EQUIPMENT SCHEDULE PLAN

SCALE: 1/8"=1'-0"

EQUIPMENT SCHEDULE

ITEM NO.	QTY	EQUIPMENT CATEGORY	MANUFACTURER	MODEL NUMBER	ITEM NO.	QTY	EQUIPMENT CATEGORY	MANUFACTURER	MODEL NUMBER
1	1	UTENSIL / PAN WASHER	HOBART US FOODSERVICE	UM50-1TVC	20	2	COLD FOOD TABLES	COLORPOINT	#KCM480-EG
2	1	MODULAR ELECTRIC TILTING BRAISING PAN	VULCAN-HART CO.	VE40	21	2	MILK COOLERS	COLORPOINT	COLORPOINT-MLK DISPENSER 12
2A	1	TRENCH DRAIN	REFER TO PLUMBING DRAWINGS	REFER TO PLUMBING DRAWINGS	22	4	STAINLESS STEEL CHASES (14 GA.) 4"X8"X10'-0" TALL	COLORPOINT	
3	2	DOUBLE OVEN, CONVECTION, ELECTRIC	BLODGETT OVEN CO.	MARK V DOUBLE	23	2	CASHER STAND	COLORPOINT	
4	1	ELECTRIC EXPANDO RANGE	VULCAN-HART	E12EP	24	7	SHELVING, PLASTIC, LOUVERED (24X48)	INTERMETRO INDUSTRIES	Q244802
5	1	COMBINATION- OVEN / STEAMER	BLODGETT OVEN	BOX-14E SINGLE	24A	8	SHELVING, PLASTIC, LOUVERED (24X80)	INTERMETRO INDUSTRIES	Q246002
6	1	HOSE REEL W/GUN	CHO/ENDORE	KHR-5835-0	24B	4	SHELVING, PLASTIC, LOUVERED (24X72)	INTERMETRO INDUSTRIES	Q247202
7	1	SINK, VEGETABLE, 2 COMPARTMENTS	ADVANCE TABCO	84-82-38-18RL	25	2	CAN RACK (35X37X71)	KEL MAX EQUIPMENT	CSR-216
7A	1	CUTTER, VEGETABLE	MANNHART, INC.	M3000-10	26	5	DUNNAGE RACK (22X60X12)	INTERMETRO INDUSTRIES	HP2250FD
8	1	SINK, SINKERY, 3 COMPARTMENTS	ADVANCE TABCO	84-83-80-36RL	27	1	WALK IN COOLER / FREEZER	THERMO-KOOL	CUSTOM
8A	1	WALL MOUNTED SHELF (12" WIDE X 13'-10" LONG)	ADVANCE TABCO	WS-12-201	28	1	AIR COOLED REFRIGERATION SYSTEMS	COLDZONE	MPL-1CZ
9	1	SLICER, FOOD	HOBART US FOODSERVICE	3813-BUILDUP	29	1	REFRIGERATOR / FREEZER WITH ICE MAKER		
10	1	CHILLER, BLAST	TRAILERSON	TB35	30	1	MICROWAVE		
11	1	MIXER, FLOOR	HOBART US FOODSERVICE	HL300-1STD	31	1	STACKABLE WASHER AND DRYER		
12	1	ICE MAKER (CUBE STYLE)	ICE-O-MATIC	ICEO400HA	32	1	FLOOR SAFE (13" X 15" X 11.5")	BROWN SAFE MFG.	LPN72-1U
13	5	WALL MOUNTED LAY.	REFER TO PLUMBING DRAWINGS	REFER TO PLUMBING DRAWINGS	33	1	MISC. VENDOR COOLER (BY OWNER)	WARS AIR SYSTEMS	BZ000 OR EQUAL
14	5	WALL MOUNTED SHELF (12" WIDE X 3' LONG)	ADVANCE TABCO	WS-12-38	34	1	AIR CURTAIN	REFER TO PLUMBING DRAWINGS	REFER TO PLUMBING DRAWINGS
15	3	SS WORKTABLE (36X72) W/ DRAWERS / O.U.SHELF	DUKE MANUFACTURING	314S-3672	35	1	FLOOR MOUNTED SERVICE SINK	REFER TO PLUMBING DRAWINGS	REFER TO PLUMBING DRAWINGS
15A	1	SS WORK TABLE (36X72) W/ POT RACK	DUKE MANUFACTURING	314S-3672	36	1	COUNTER MOUNTED SINK	REFER TO PLUMBING DRAWINGS	REFER TO PLUMBING DRAWINGS
16	2	CABINET, HEATED, PASS-THRU	TRAILERSON	8-FT12WP-HE					
17	2	CABINET, REFRIGERATED, PASS-THRU	TRAILERSON	8-FT12WP-REF					
18	2	TRAY STAND	COLORPOINT	PK-38-STE-MGD					
19	2	HOT FOOD TABLES	COLORPOINT	FEPS-CPA-EB					

A1 EQUIPMENT SCHEDULE

SCALE: N/A



DAAG ARCHITECTURE
400 S. POLARIS PLAZA - 17B, 20A
POMEREOIA, IL 60467
TELEPHONE: 815/439-0000 FAX: 815/439-0001
WWW.DAAG.COM

CONSTRUCTION DOCUMENTS
(PHASE II)

Chumuckla Elementary
Kitchen & Cafeteria Addition

KITCHEN EQUIPMENT PLAN / SCHEDULE

Project No.: 12034

Drawing Title:

Drawing No.: A101.3

Drawn By: OEG

Checked By: OEG

Date: 11-27-12

Revision:

NO. BY DATE

1. OEG 11-27-12

2. OEG 11-27-12

3. OEG 11-27-12

4. OEG 11-27-12

5. OEG 11-27-12

6. OEG 11-27-12

7. OEG 11-27-12

8. OEG 11-27-12

9. OEG 11-27-12

10. OEG 11-27-12

11. OEG 11-27-12

12. OEG 11-27-12

13. OEG 11-27-12

14. OEG 11-27-12

15. OEG 11-27-12

16. OEG 11-27-12

17. OEG 11-27-12

18. OEG 11-27-12

19. OEG 11-27-12

20. OEG 11-27-12

21. OEG 11-27-12

22. OEG 11-27-12

23. OEG 11-27-12

24. OEG 11-27-12

25. OEG 11-27-12

26. OEG 11-27-12

27. OEG 11-27-12

28. OEG 11-27-12

29. OEG 11-27-12

30. OEG 11-27-12

31. OEG 11-27-12

32. OEG 11-27-12

33. OEG 11-27-12

34. OEG 11-27-12

35. OEG 11-27-12

36. OEG 11-27-12

37. OEG 11-27-12

38. OEG 11-27-12

39. OEG 11-27-12

40. OEG 11-27-12

41. OEG 11-27-12

42. OEG 11-27-12

43. OEG 11-27-12

44. OEG 11-27-12

45. OEG 11-27-12



DAY & NIGHT ARCHITECTS
405 PALMER PLACE • 2ND FL
POMONA, IL 60457
TEL: 630.834.4444 FAX: 630.834.4445
WWW.DAGARCHITECTS.COM

CONSTRUCTION DOCUMENTS
(PHASE II)

Chumuckla Elementary
Kitchen & Cafeteria Addition

Revision

Rev	By	Description

 
Drawn By: WSB
Checked By: OEG

Date: 11-27-12

Project No.: 12034


Drawing Title:
EXTERIOR ELEVATIONS

Drawing No.: A201




B1 EXISTING SOUTH ELEVATION

 SCALE: 3/32"=1'-0"



B2 EXISTING NORTH ELEVATION

 SCALE: 3/32"=1'-0"



A1 EXISTING EAST ELEVATION

SCALE: 3/32"=1'-0"