


CEILING TYPES AND MATERIALS	
	TYPICAL 2' X 2' SUSPENDED CEILING GRID WITH ACOUSTICAL CEILING PANELS
	SUSPENDED GYPSUM BOARD CEILING
	EXPOSED TO STRUCTURE CEILING
	MANUFACTURED METAL BUILDING METAL SOFFIT PANELS
LIGHTING, VENTS AND CEILING OUTLETS	
	FLUORESCENT LIGHT FIXTURE
	FLUORESCENT LIGHT FIXTURE WITH EMERGENCY POWER
	FLUORESCENT LIGHT FIXTURE
	FLUORESCENT LIGHT FIXTURE WITH EMERGENCY POWER
	CEILING MOUNTED FLUORESCENT LIGHT FIXTURE
	CEILING MOUNTED FLUORESCENT LIGHT FIXTURE w/ EMERGENCY POWER
	WALL MOUNTED FLOURESCENT LIGHT FIXTURED
	SUSPENDED FLUORESCENT LIGHT FIXTURE
	WALL MOUNTED LIGHT FIXTURE
	RECESSED CEILING LIGHTFIXTURE
	CANOPY SURFACE MOUNTED FIXTURE
	2x2 SUPPLY AIR VENT
	SUPPLY AIR VENT
	2X2 RETURN AIR VENT
	EXHAUST AIR GRILLE
	RETURN AIR VENT

C1	REFLECTED CEILING PLAN
SCALE: 1/8" = 1'-0"	

C2	RCP LEGEND
SCALE: 1/8"=1'-0"	

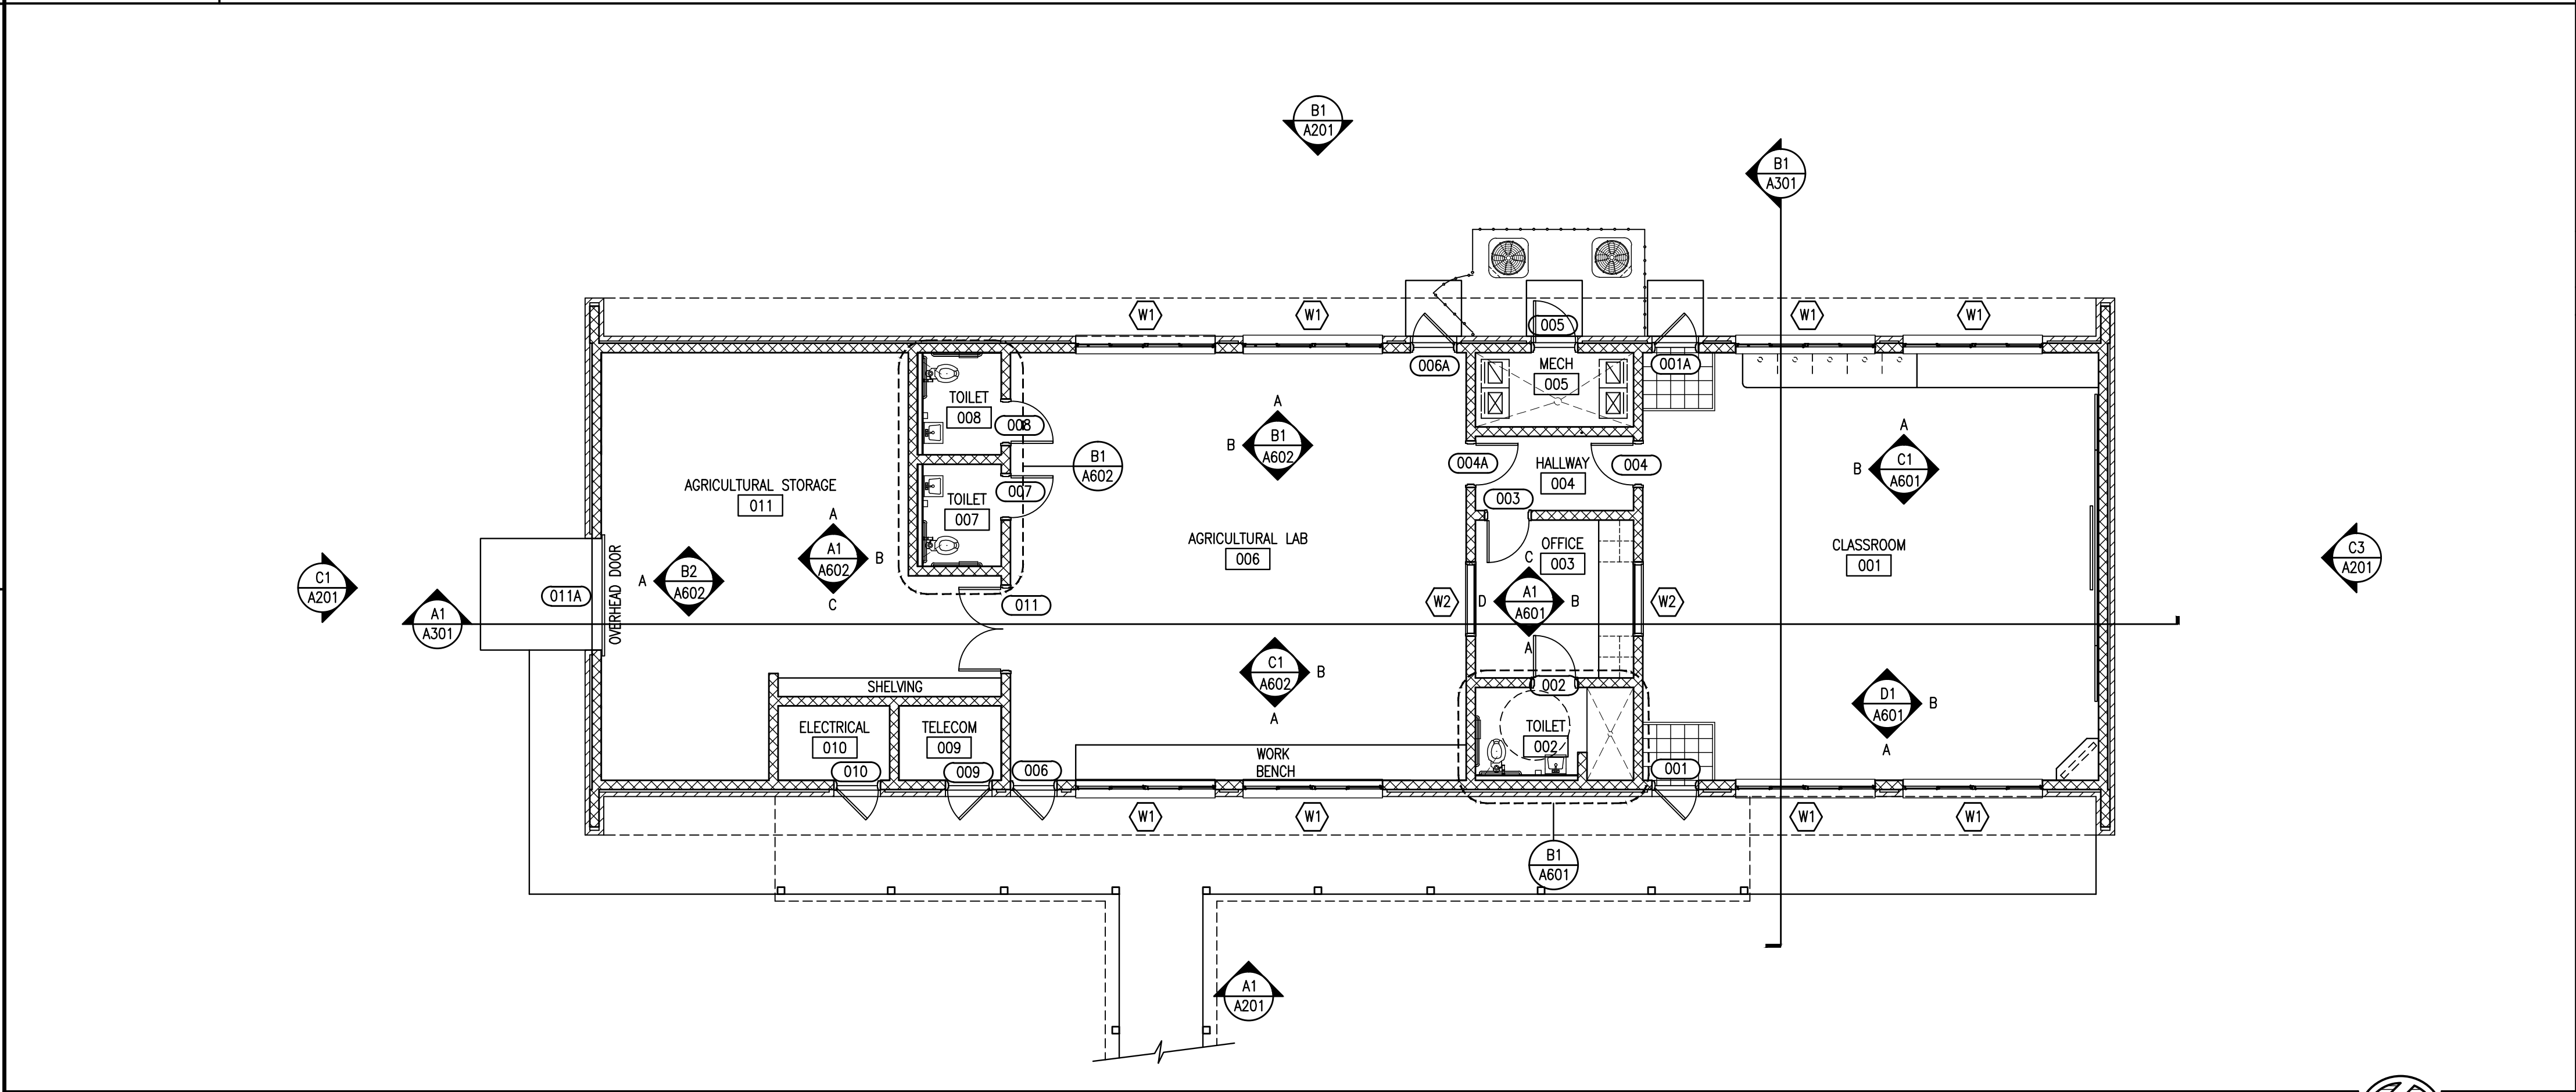

GENERAL CEILING NOTES	
1. SEE FINISH SCHEDULE AND BUILDING SECTIONS FOR CEILING HEIGHTS A.F.F. 2. CONTRACTOR SHALL COORDINATE FIXTURE LOCATION AND TYPE WITH THE ELECTRICAL DRAWINGS 3. CONTRACTOR SHALL COORDINATE ALL LIFE SAFETY SYSTEMS, SIGNAGE, FIXTURES AND ALARMS WITH THE ELECTRICAL DRAWINGS. 4. COORDINATE LOCATION OF MECHANICAL DIFFUSERS, GRILLES, AND DAMPERS W/ MECHANICAL DRAWINGS, ELECTRICAL, AND LIFE SAFETY PLANS.	
B2	RCP GEN. NOTES
SCALE: NTS	

A1	FLOOR PLAN
SCALE: 1/8" = 1'-0"	

DAG ARCHITECTS INC.  
40 S. PALAFOX PLACE - STE 201  
PENSACOLA, FL 32502  
TELEPHONE: 850-429-9004 FAX: 850-429-9005  
AA-C000745

OWNERSHIP OF INSTRUMENTS OF SERVICE  
ALL REPORTS, PLANS, SPECIFICATIONS, COMPUTER FILES, FIELD DATA, NOTES AND OTHER DOCUMENTS AND INSTRUMENTS PREPARED BY THE CONSULTANT AS INSTRUMENTS OF SERVICE SHALL REMAIN THE PROPERTY OF THE CONSULTANT. THE CONSULTANT SHALL RETAIN ALL COMMON LAW, STATUTORY AND OTHER RESERVED RIGHTS, INCLUDING THE COPYRIGHT THERE TO.

PHASE 2 - DOCUMENTS

Central School  
Ag Classroom / Lab Addition

6180 Central School Road, Milton, FL 32570

NOT FOR CONSTRUCTION

Revision		
Date:	No.	Description:
03/24/15	1	ADDENDUM #1
-	-	-
-	-	-
-	-	-
-	-	-
-	-	-
-	-	-
-	-	-
-	-	-
Drawn By: OEG		
Checked By: OEG		
Date: 04-18-2016		
Project No.: 16002		
Drawing Title:		
FLOOR PLAN AND REFLECTED CEILING PLAN		
Drawing No.: A101		