


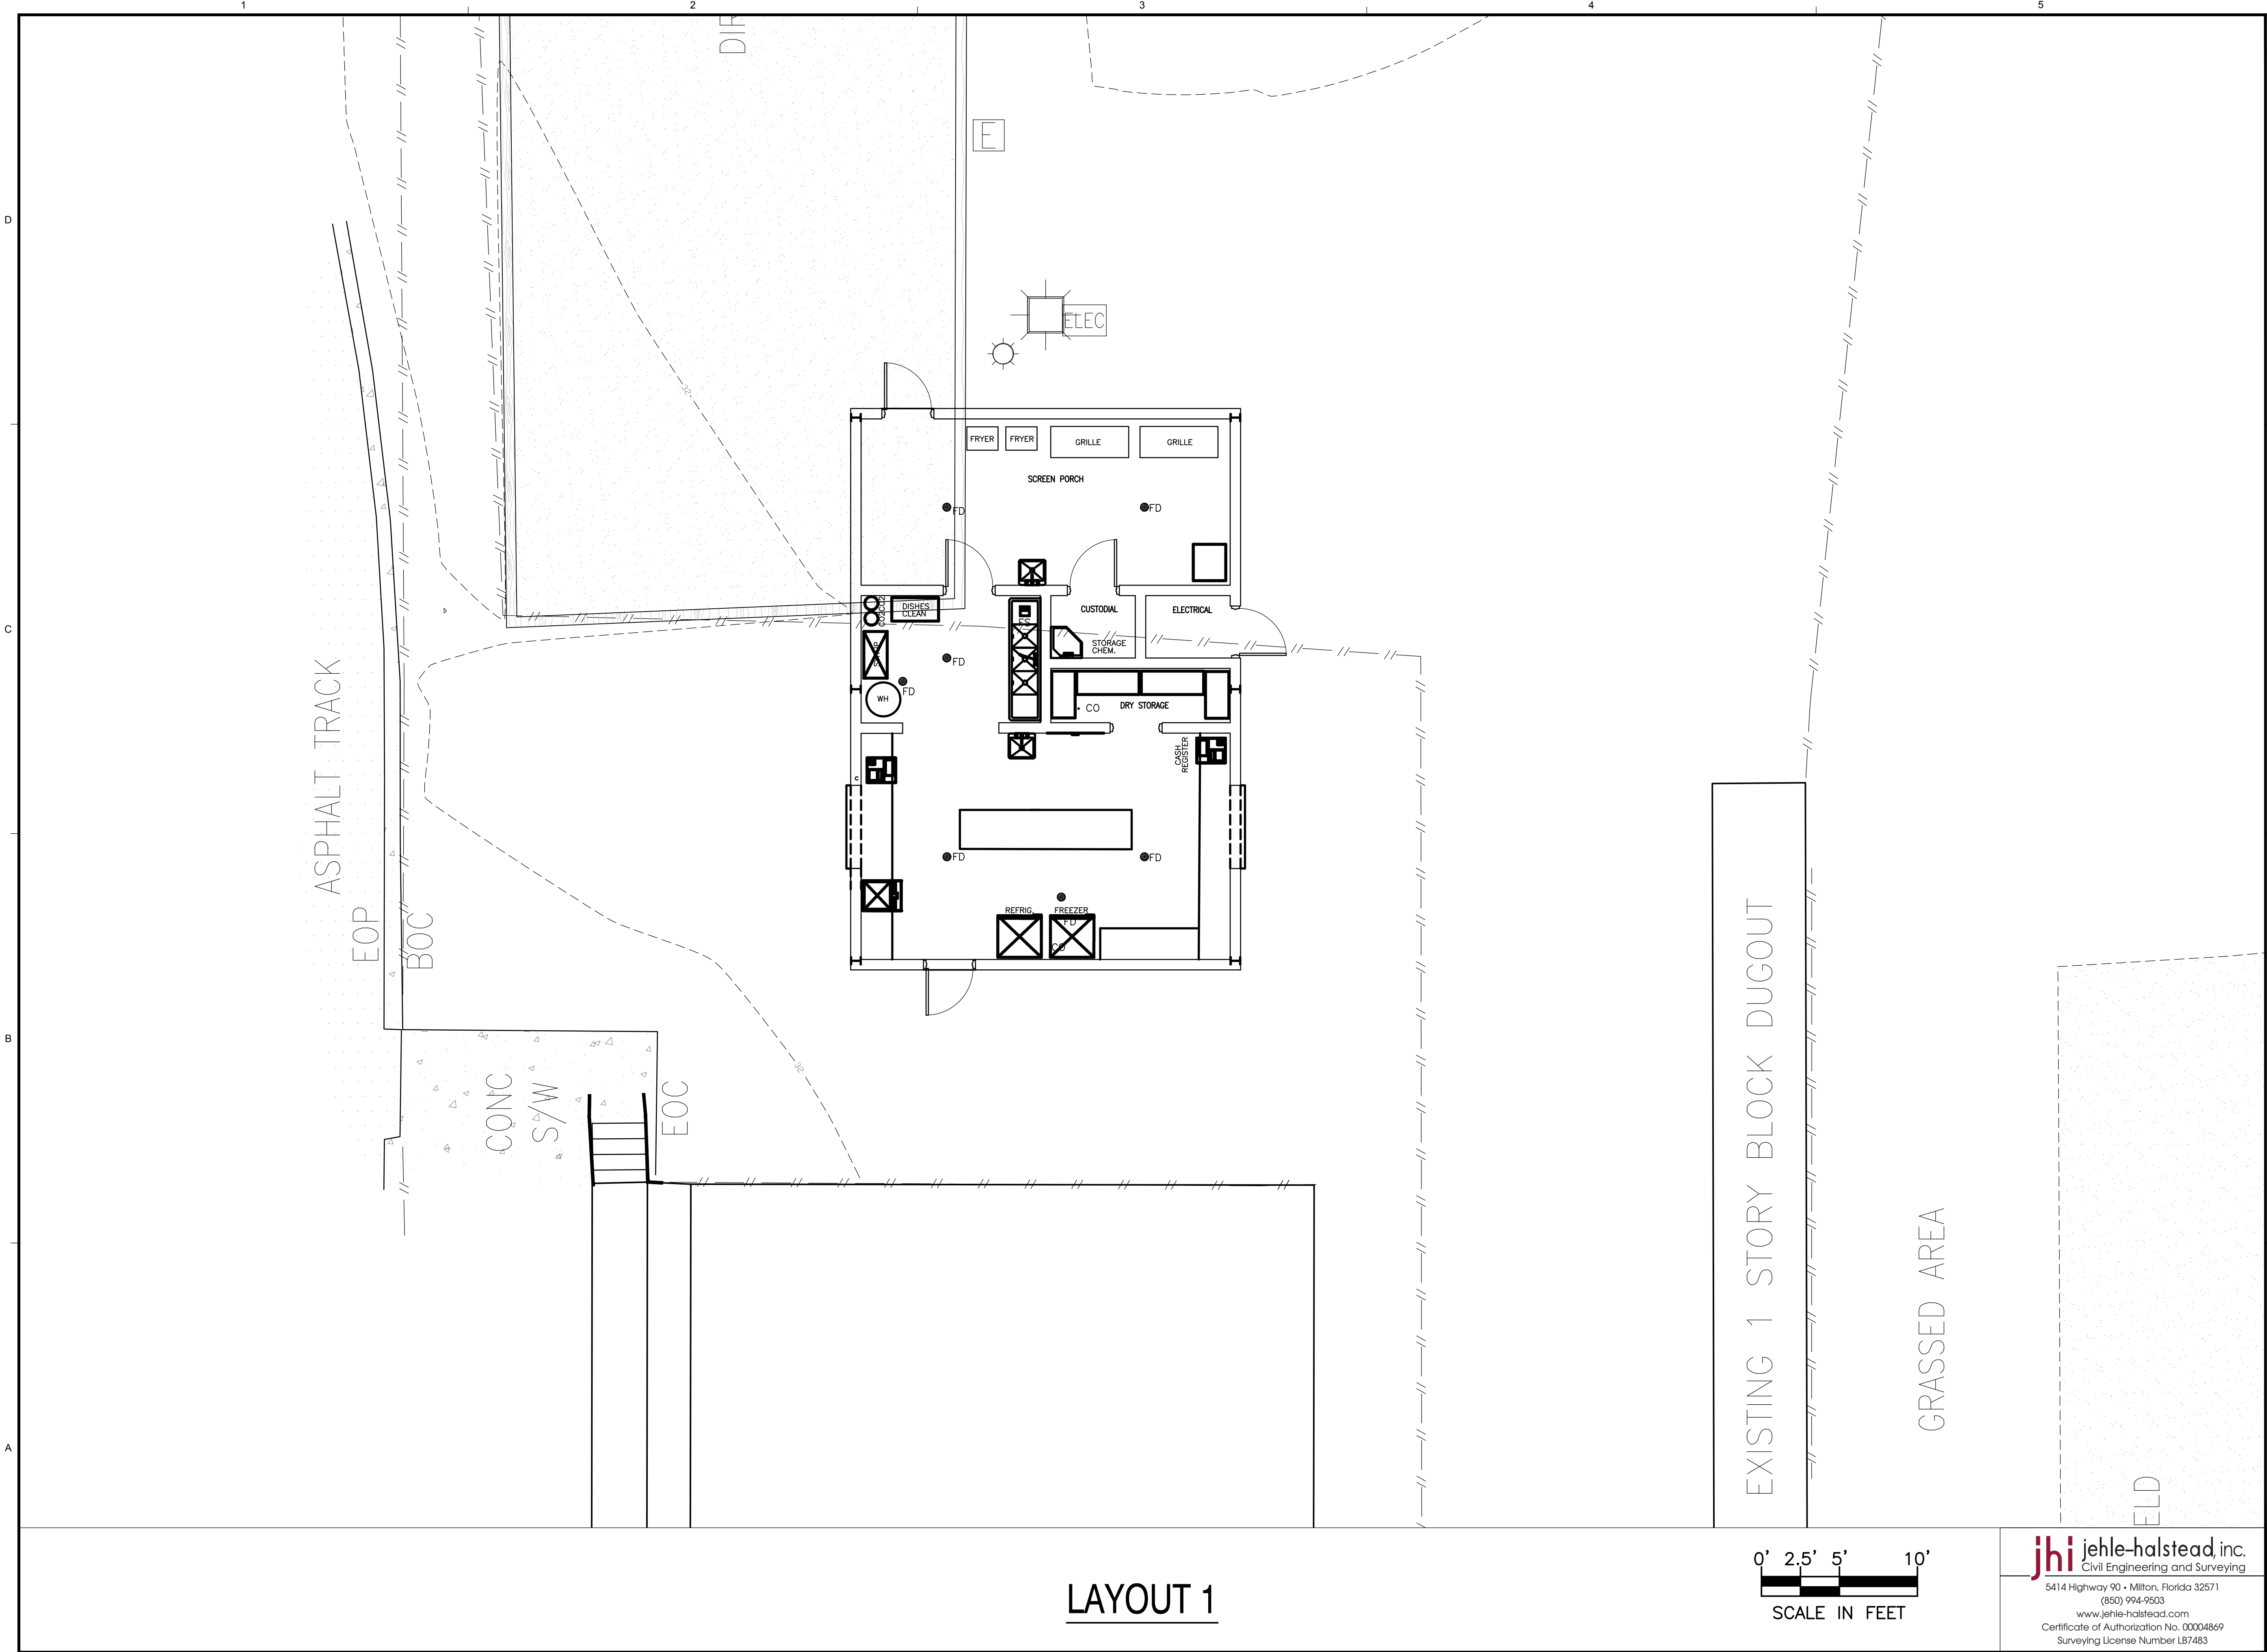

DAG ARCHITECTS INC.
40 S. PALAFOX PLACE - STE 201
PENSACOLA, FL 32502
TELEPHONE: 850-429-9004 FAX: 850-429-9005
AA-C000745

OWNERSHIP OF INSTRUMENTS OF SERVICE
ALL REPORTS, PLANS, SPECIFICATIONS, COMPUTER FILES, FIELD DATA, NOTES AND OTHER DOCUMENTS AND INSTRUMENTS PREPARED BY THE CONSULTANT AS INSTRUMENTS OF SERVICE SHALL REMAIN THE PROPERTY OF THE CONSULTANT. THE CONSULTANT SHALL RETAIN ALL COMMON LAW, STATUTORY AND OTHER RESERVED RIGHTS, INCLUDING THE COPYRIGHT THERETO.

SCHEMATIC DESIGN (PHASE I)

Navarre High School North Concession Stand

8600 High School Blvd.
Navarre, FL 32566

D. PATRICK JEHL JR
P.E. 71528

Revision

[illegible]

Drawn By: JDG/GPE
Checked By: DPJJ

Date: 11-13-17


Project No.: 170062

Drawing Title:

CIVIL NOTES & INFORMATION

Drawing No.:

C000

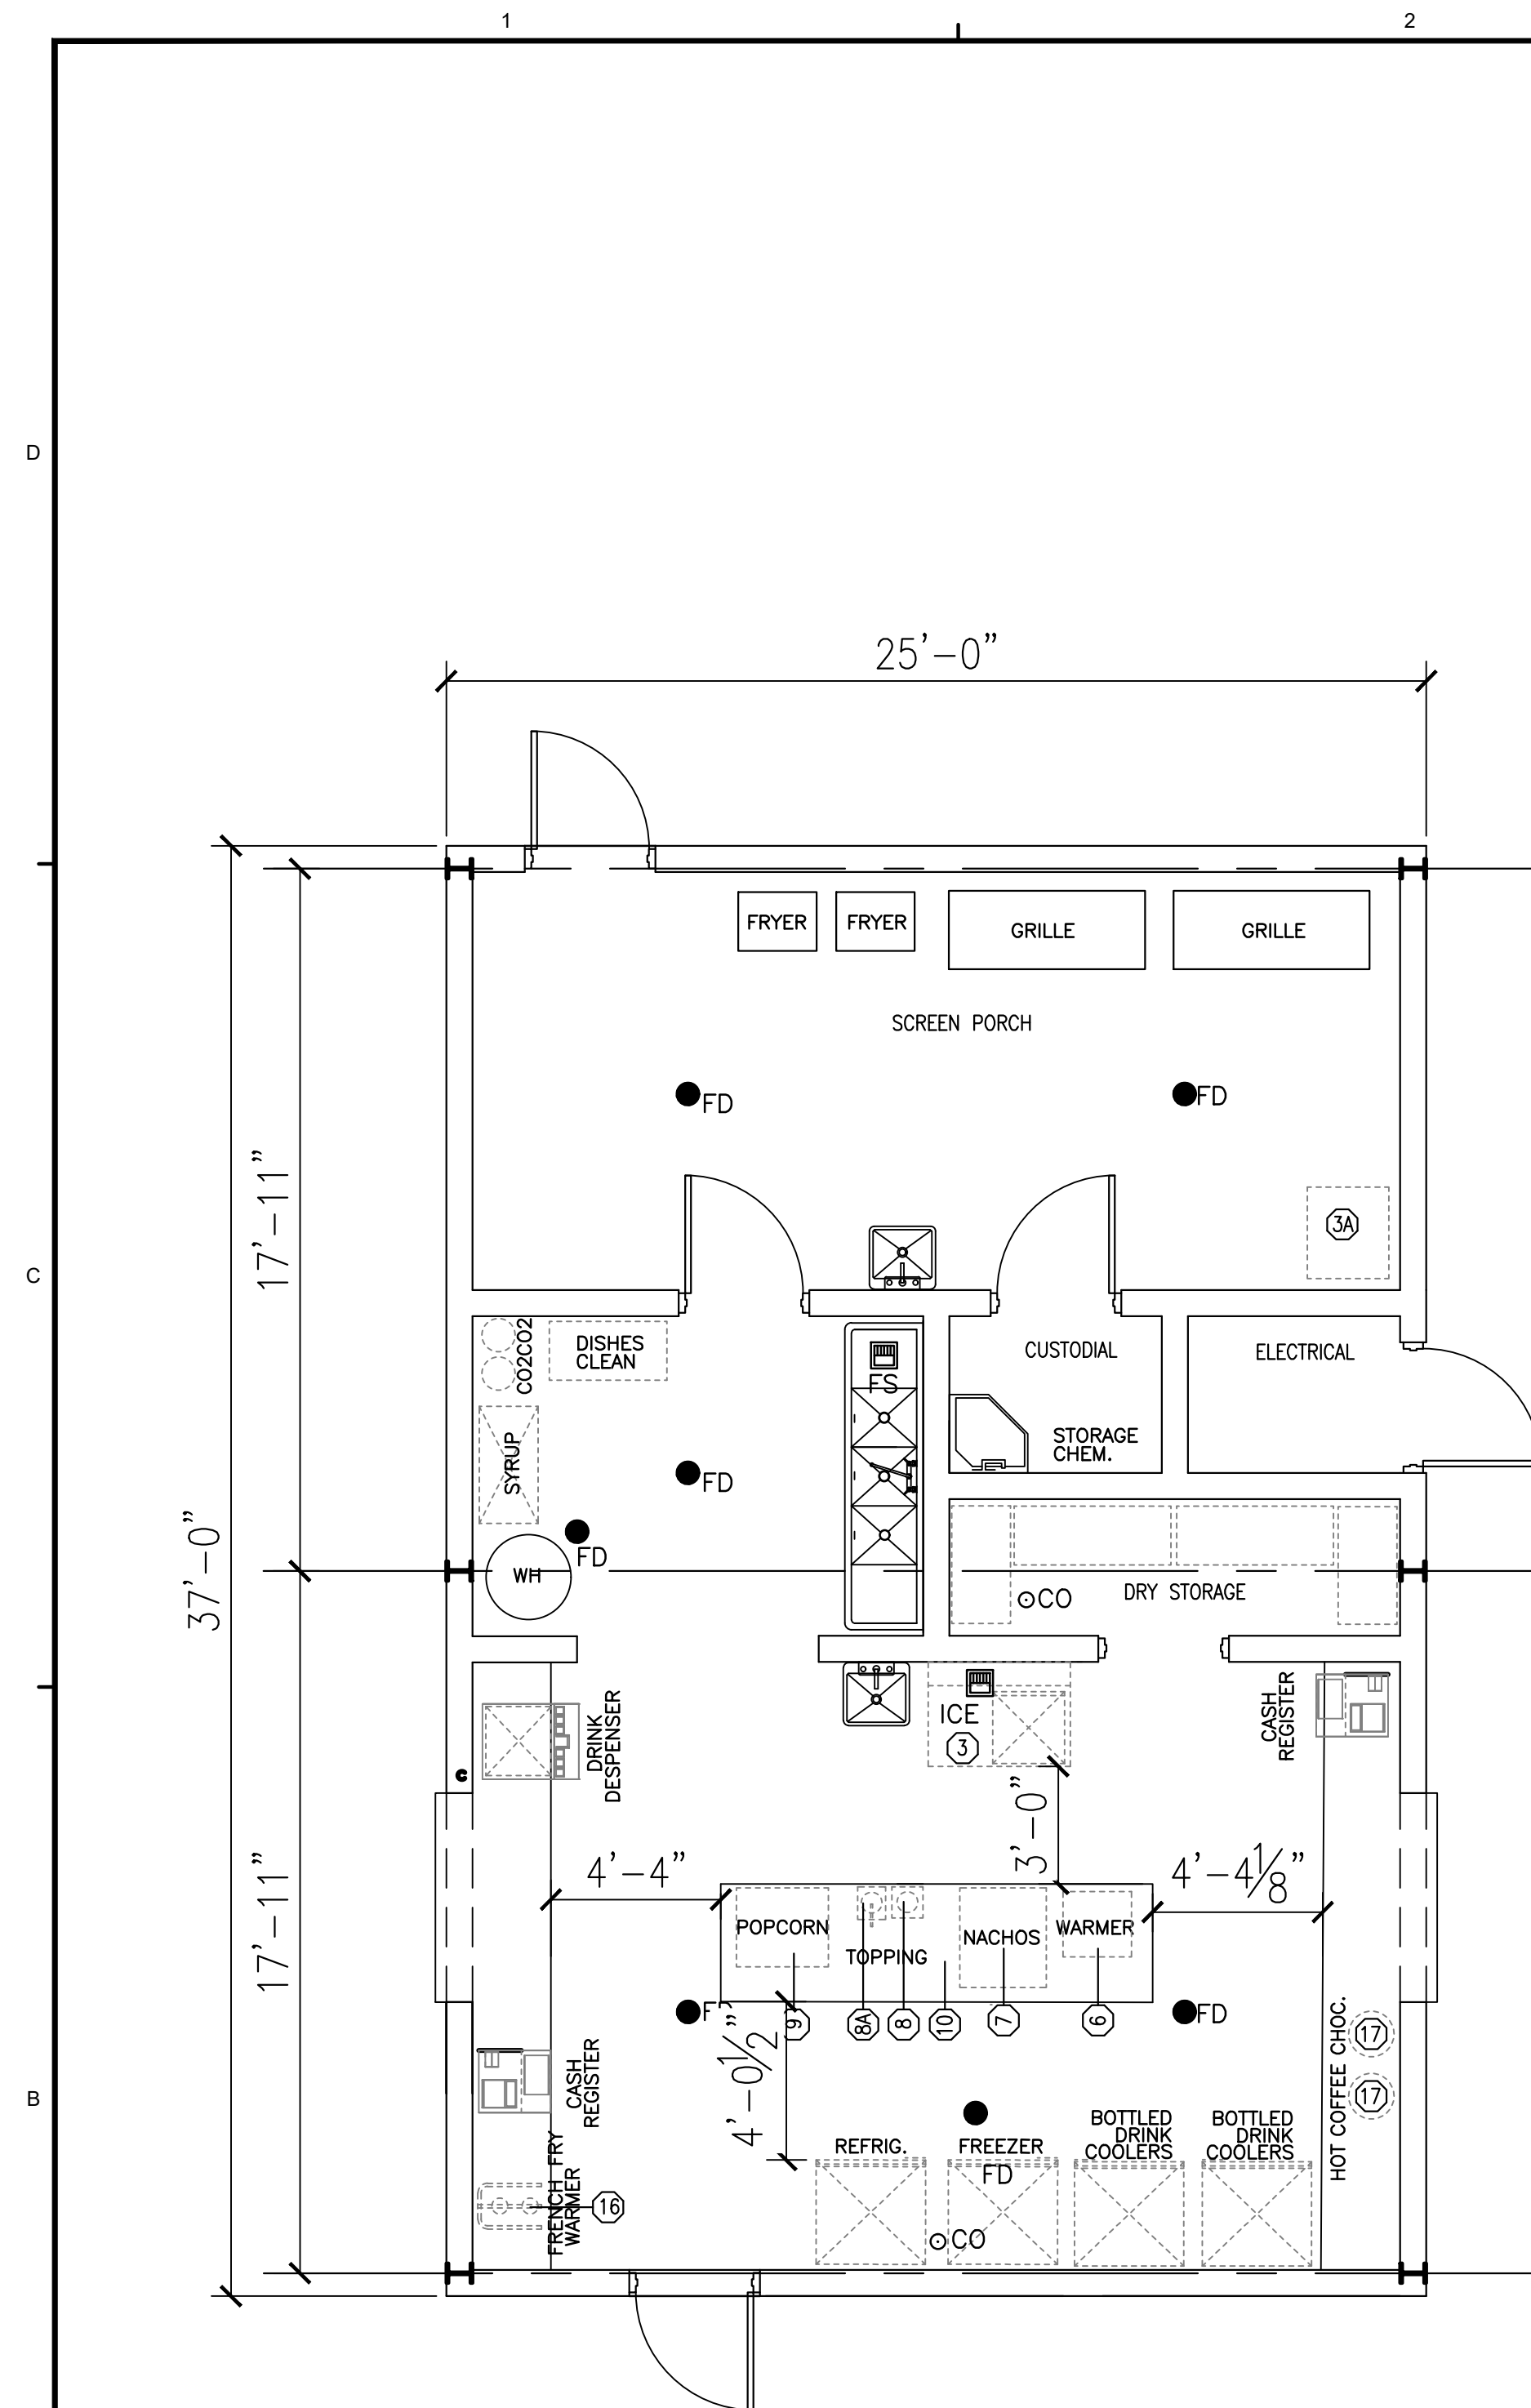

ITEM NO.	QUANTITY	DESCRIPTION	MANUFACTURER / MODEL NO.	DIMENSION	POWER REQ.	WATER REQ.
①	1	STAINLESS STEEL COUNTER ASSEMBLY WITH 3 PASS THRU'S, OPEN AT BASE	CUSTOM	28"-8" L X 2'-6" D	-	-
②	3	HAND SINK	ADVANCE TABCO / 7-PS-20-NF-2X			
③	1	ICE CUBER	MANITOWOC ID-0592N			
③A	1	REMOTE CONDENSING UNIT		25" W X 28" D		
④	1	REACH IN REFRIGERATOR (BY OWNER)				
⑤	1	REACH IN FREEZER (BY OWNER)				
⑥	2	HOT FOOD MERCHANDISER (WARMER)	HATCO FDWD-1X-120-QS	19.39W X 20.86"D		
⑦	1	CHIP WARMER	VULCAN VCW26	26 1/2"W X 30 1/2"D		
⑧	1	FOOD TOPPING WARMER (4 QT. CAPACITY)	APW WYOTT W-4B PKG	9 1/2"W X 9 1/2"D		
⑧A	1	HEATED PUMP WARMER	APW WYOTT LCCW	8 1/2"W X 14 1/4"D		
⑨	1	POPCORN POPPER	STAR G12-Y	21 1/8"W X 21 1/8"D		
⑩	2	STAINLESS STEEL TABLES W/ ADJUSTABLE UNDER SHELF W/ 3 DRAWERS	ADVANCE TABCO SKG-3612	14'-0" L X 3'-0" D		
⑪	2	STAINLESS STEEL COUNTER ASSEMBLY WITH PASS THRU, OPEN AT BASE	CUSTOM	10'-0" L X 2'-6" D		
⑫	1	THREE COMPARTMENT SINK	ADVANCE TABCO FS-3-1824-18RL	7'-6" L X 29 1/2" D		
⑬	2	WIRE SHELVING - 2 SHELVING UNITS (8 SHELVES TOTAL)	OLYMPIC J1836C	36"L X 18"D X 74" H		
⑭	2	WIRE SHELVING - 1 SHELVING UNIT (4 SHELVES TOTAL)	OLYMPIC J1848C	48"L X 18"D X 74" H		
⑮		MICROWAVE (BY OWNER)				
⑯	1	2 BULB INFRARED FRENCH FRY FOOD WARMER	NEMCO 6000A-2	14" W X 19 1/2" D		
⑰	2	COFFEE URN (BY OWNER)				

ADDITIONAL EQUIPMENT/FURNITURE:

CASH REGISTERS
DRINK DISPENSERS
BOTTLED DRINK COOLERS
FRYERS
GRILLS
FOOD PREP TABLE
DISH CART

A1	Floor Plan
SCALE: 1/4"=1'-0"	

A2	Equipment
SCALE: 1/4"=1'-0"	



DAG ARCHITECTS INC.
40 S. PALAFOX PLACE - STE 201
PENSACOLA, FL 32502
TELEPHONE: 850-429-9004 FAX: 850-429-9005
AA-C000745

OWNERSHIP OF INSTRUMENTS OF SERVICE
ALL REPORTS, PLANS, SPECIFICATIONS, COMPUTER FILES, FIELD DATA, NOTES AND OTHER DOCUMENTS AND INSTRUMENTS PREPARED BY THE CONSULTANT AS INSTRUMENTS OF SERVICE SHALL REMAIN THE PROPERTY OF THE CONSULTANT. THE CONSULTANT SHALL RETAIN ALL COMMON LAW, STATUTORY AND OTHER RESERVED RIGHTS, INCLUDING THE COPYRIGHT THERETO.

SCHEMATIC
DESIGN
(PHASE I)

Navarre High School
North Concession Stand
8600 High School Blvd.
Navarre, FL 32566

[illegible]

Drawn By: -
Checked By: -

Date: 12-05-17

Project No.: 170XX

Drawing Title:

FLOOR PLAN

Drawing No.: **A101**