

SOFTBALL FIELDHOUSE
AT
PACE HIGH SCHOOL
NORRIS RD.
PACE, FL 32565

FOR THE
SCHOOL BOARD OF
SANTA ROSA COUNTY
PHASE III
DOCUMENTS

PROJECT INDEX:

GENERAL:

A000 SET COVER SHEET - PROJECT STATS, SHEET INDEX, DESIGN TEAM
A010 ABBREVIATIONS & SYMBOLS

CIVIL SHEETS:

C000 - NOTES AND INFORMATION
C001 - EXISTING SITE CONDITIONS
C002 - SITE DEMOLITION PLAN
C003 - SITE IMPROVEMENTS PLAN
C004 - SITE DIMENSIONING PLAN
C005 - SITE GRADING PLAN
C006 - SITE STORMWATER PLAN
C007 - SITE UTILITY PLAN
C008 - SITE CONSTRUCTION DETAILS
C009 - SITE STORMWATER & UTILITY DETAILS
C010 - SITE STORMWATER & UTILITY DETAILS
C011 - SITE EROSION CONTROL DETAILS

STRUCTURAL SHEETS:

S001 - GENERAL NOTES AND TYPICAL DETAILS
S101 - FOUNDATION PLAN, SECTIONS AND DETAILS
S102 - ROOF FRAMING PLAN, TYPICAL JOIST AND DECK DETAILS
S201 - SECTIONS AND DETAILS

ARCHITECTURAL SHEETS:

LS101 LIFE SAFETY PLAN
A100 ARCHITECTURAL SITE PLAN & CONSTRUCTION ACCESS PLAN
A101 FLOOR PLAN
A101.1 DIMENSION PLAN
A101.2 REFLECTED CEILING PLAN
A101.3 ROOF PLAN
A101.4 FINISH & SIGNAGE PLAN
A201 EXTERIOR ELEVATIONS
A301 BUILDING SECTIONS,STAIR & RAMP SECTIONS
A310 PARTITION TYPES
A311 WALL SECTIONS
A312 WALL SECTIONS
A330 SECTION DETAILS
A331 DETAILS
A501 DOOR, FRAME, & WINDOW SCHEDULE
A502 DOOR & WINDOW DETAILS
A601 ENLARGED PLANS & INTERIOR ELEVATIONS
A611 CASEWORK DETAILS

PLUMBING:

P001 - PLUMBING LEGEND
P002 - PLUMBING LEGEND
P101 - SANITARY & VENT PLAN
P201 - DOMESTIC WATER PLAN
P301 - RISER DIAGRAMS
P401 - PLUMBING DETAILS
P402 - PLUMBING DETAILS

MECHANICAL:

M001 - MECHANICAL LEGEND
M002 - MECHANICAL LEGEND
M101 - MECHANICAL NEW WORK
M201 - MECHANICAL DETAILS
M202 - MECHANICAL DETAILS
M301 - MECHANICAL CONTROLS

ELECTRICAL:

E100 - ELECTRICAL SITE PLAN
E001 - ELECTRICAL LEGEND
E201 - ELECTRICAL LIGHTING PLAN
E202 - ELECTRICAL POWER PLAN
E301 - ELECTRICAL DETAILS
E302 - ELECTRICAL DETAILS
E303 - ELECTRICAL DETAILS

OWNER CONTACTS:

Santa Rosa County School Board
Santa Rosa County, FL
Phone: 850-983-5123
Fax: 850-983-5115

Joseph B. Harrell
Assistant Superintendent for
Administrative Services
Email:
Harrelj@mail.santarosa.k12.fl.us

ARCHITECT:

DAG Architects, Inc.
40 South Palafox Place, Suite 201
Pensacola, Florida 32502
Phone: 850-429-9004
Fax: 850-429-9005

PIC: Dave Luttrell, AIA
PM: Owen Gipson, AIA
Email: ogipson@dagarchitects.com

STRUCTURAL:

Berube-Leonard, LLC
3101 N. 12th Ave
Suite 102
Pensacola, FL 32503
Phone: 850-473-9955 Ext 3
Fax: 850-473-1770

PIC: Stephen W Leonard, PE
Email: steve@blse.net

Applicable Building Codes

- a. Florida Building Code (FBC) 2017 Sixth Edition - Referenced Below, Unless Noted
Otherwise
b. NFPA Life Safety Code - 2014 Edition
c. National Electric Code
d. County Codes
e. City Codes

FLORIDA BUILDING CODE:
OCCUPANCY: GROUP E
CONSTRUCTION: TYPE IIB, UNSPRINKLERED,

EXPOSURE: C
ULTIMATE DESIGN WIND SPEED: 160 MPH
TYPE OF CONSTRUCTION: IIB
RISK CATEGORY: III
OCCUPANCY: GROUP E EDUCATIONAL
OCCUPANT LOAD: 49
SQUARE FOOTAGE: 2448 SF +/-
EGRESS CALCULATIONS: SEE LS101


FLORIDA PRODUCT APPROVAL NUMBERS

PRODUCT MANUFACTURER	ITEM	APPROVAL TYPE	APPROVAL NUMBER
STEELCRAFT H-SERIES	EXTERIOR HOLLOW METAL DOORS	STATE	FL-12400
BERRIDGE	STANDING SEAM METAL ROOFING	STATE	FL-11159.3
WINCO	WINDOWS - SLIDERS 3410	STATE	FL-22662.1 (impact)
KAWNEER	IR-501 (BASIS OF DESIGN)	STATE	FL-8787.2 (impact)

B4

Project Sheet Index

SCALE: NTS

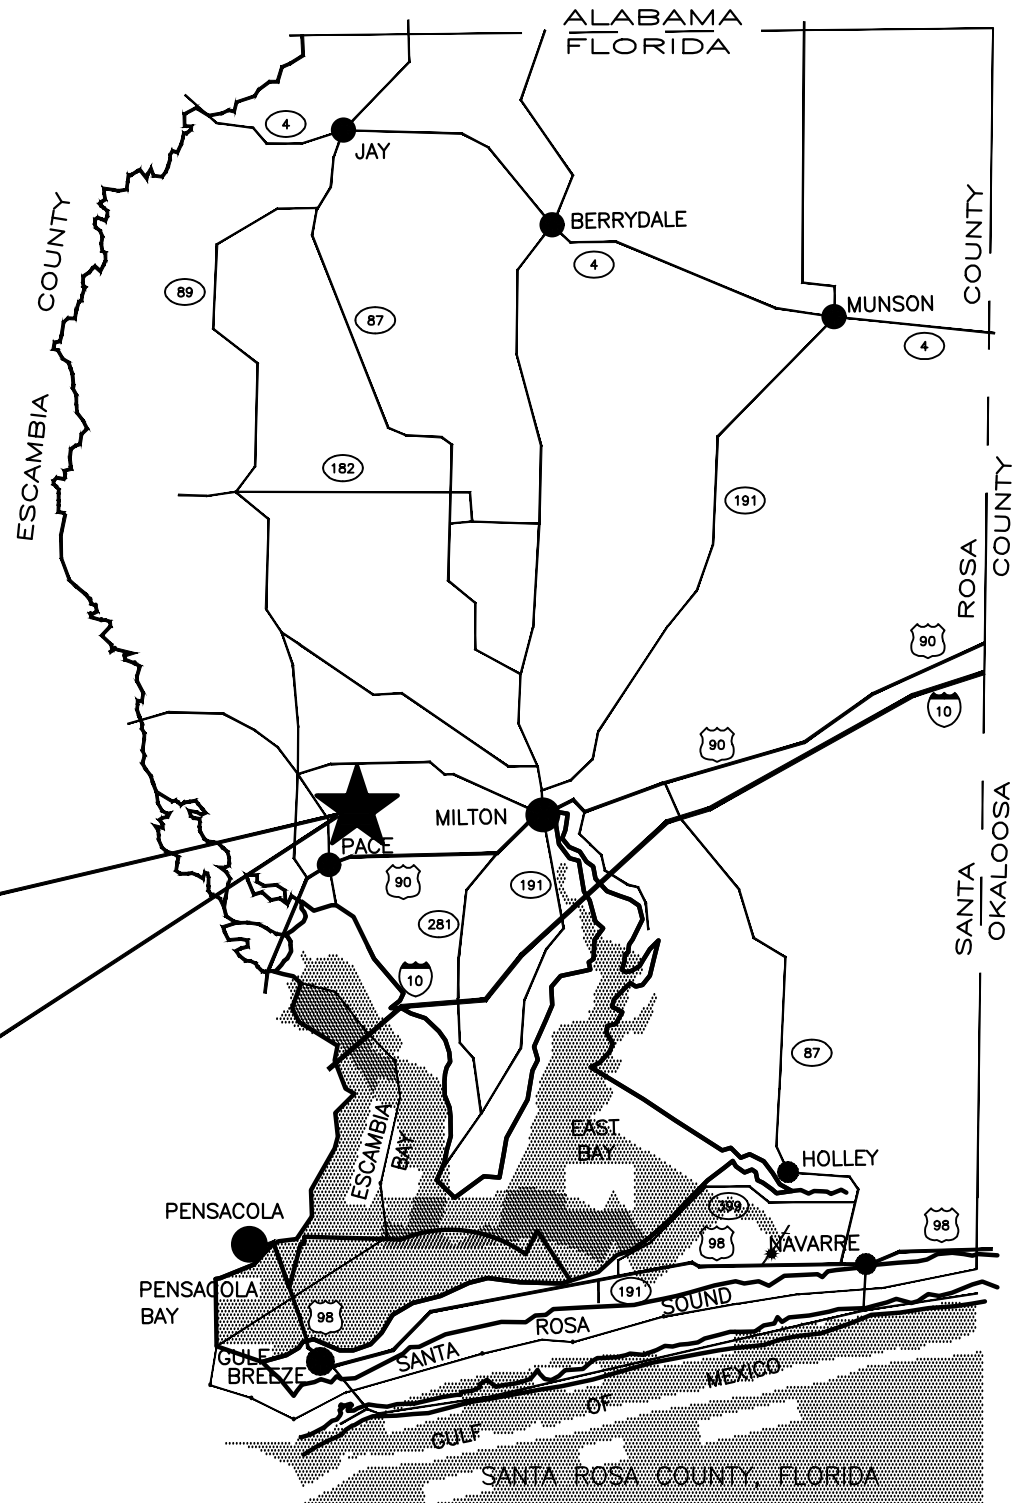

PROJECT LOCATION:
PACE HIGH SCHOOL
4065 NORRIS RD
PACE, FL 32571

ELECTRICAL:

Schmidt Consulting Group, Inc.
901 West Garden Street
Pensacola, FL 32502
Phone: 850-438-0050
Fax: 850-432-8631

Todd Nicholson, PE
Email: toddn@schmidtconsulting
group.com

TELECOMMUNICATIONS:

Schmidt Consulting Group, Inc.
901 West Garden Street
Pensacola, FL 32502
Phone: 850-438-0050
Fax: 850-432-8631

Todd Nicholson, PE
Email: toddn@schmidtconsulting
group.com

CIVIL & SURVEYING:

Jehle-Halstead, Inc.
5414 Highway 90
Milton, FL 32571
Phone: 850-994-9503
Fax: 850-994-9504

Patrick Jehle, Jr. E.I.
Email: pjehle@jehle-halstead.com

PLUMBING:

Schmidt Consulting Group, Inc.
901 West Garden Street
Pensacola, FL 32502
Phone: 850-438-0050
Fax: 850-432-8631

Joe Jones
Email: joe@schmidtconsulting
group.com

MECHANICAL:

Schmidt Consulting Group, Inc.
901 West Garden Street
Pensacola, FL 32502
Phone: 850-438-0050
Fax: 850-432-8631

Joe Jones
Email: joe@schmidtconsulting
group.com

A1

SCALE: NTS

Project Teams and Discipline
Allocation

A3

SCALE: NTS

Building Code Data

A4

SCALE: NTS

Vicinity Map



DAG ARCHITECTS INC.
40 S. PALAFOX PLACE - STE 201
PENSACOLA, FL 32502
TELEPHONE: 850-429-9004 FAX: 850-429-9005
AA-C000745

OWNERSHIP OF INSTRUMENTS OF SERVICE
ALL REPORTS, PLANS, SPECIFICATIONS, COMPUTER FILES, FIELD DATA,
NOTES AND OTHER DOCUMENTS AND INSTRUMENTS PREPARED BY
THE CONSULTANT AS INSTRUMENTS OF SERVICE SHALL REMAIN THE
PROPERTY OF THE CONSULTANT. THE CONSULTANT SHALL RETAIN ALL
COMMON LAW, STATUTORY AND OTHER RESERVED RIGHTS,
INCLUDING THE COPYRIGHT THERE TO.

PHASE III
DOCUMENTS

Pace High School
Softball Fieldhouse
4065 Norris Rd.
Pace, FL 32571

Revision

Date:	No.	Description:

Drawn By: SJT
Checked By: DAG


Date: 11-29-18

Project No.: 18045

Drawing Title:
SET COVER SHEET -
PROJECT STATS, CODE REVIEW
SHEET INDEX & DESIGN TEAM

Drawing No.:

A000

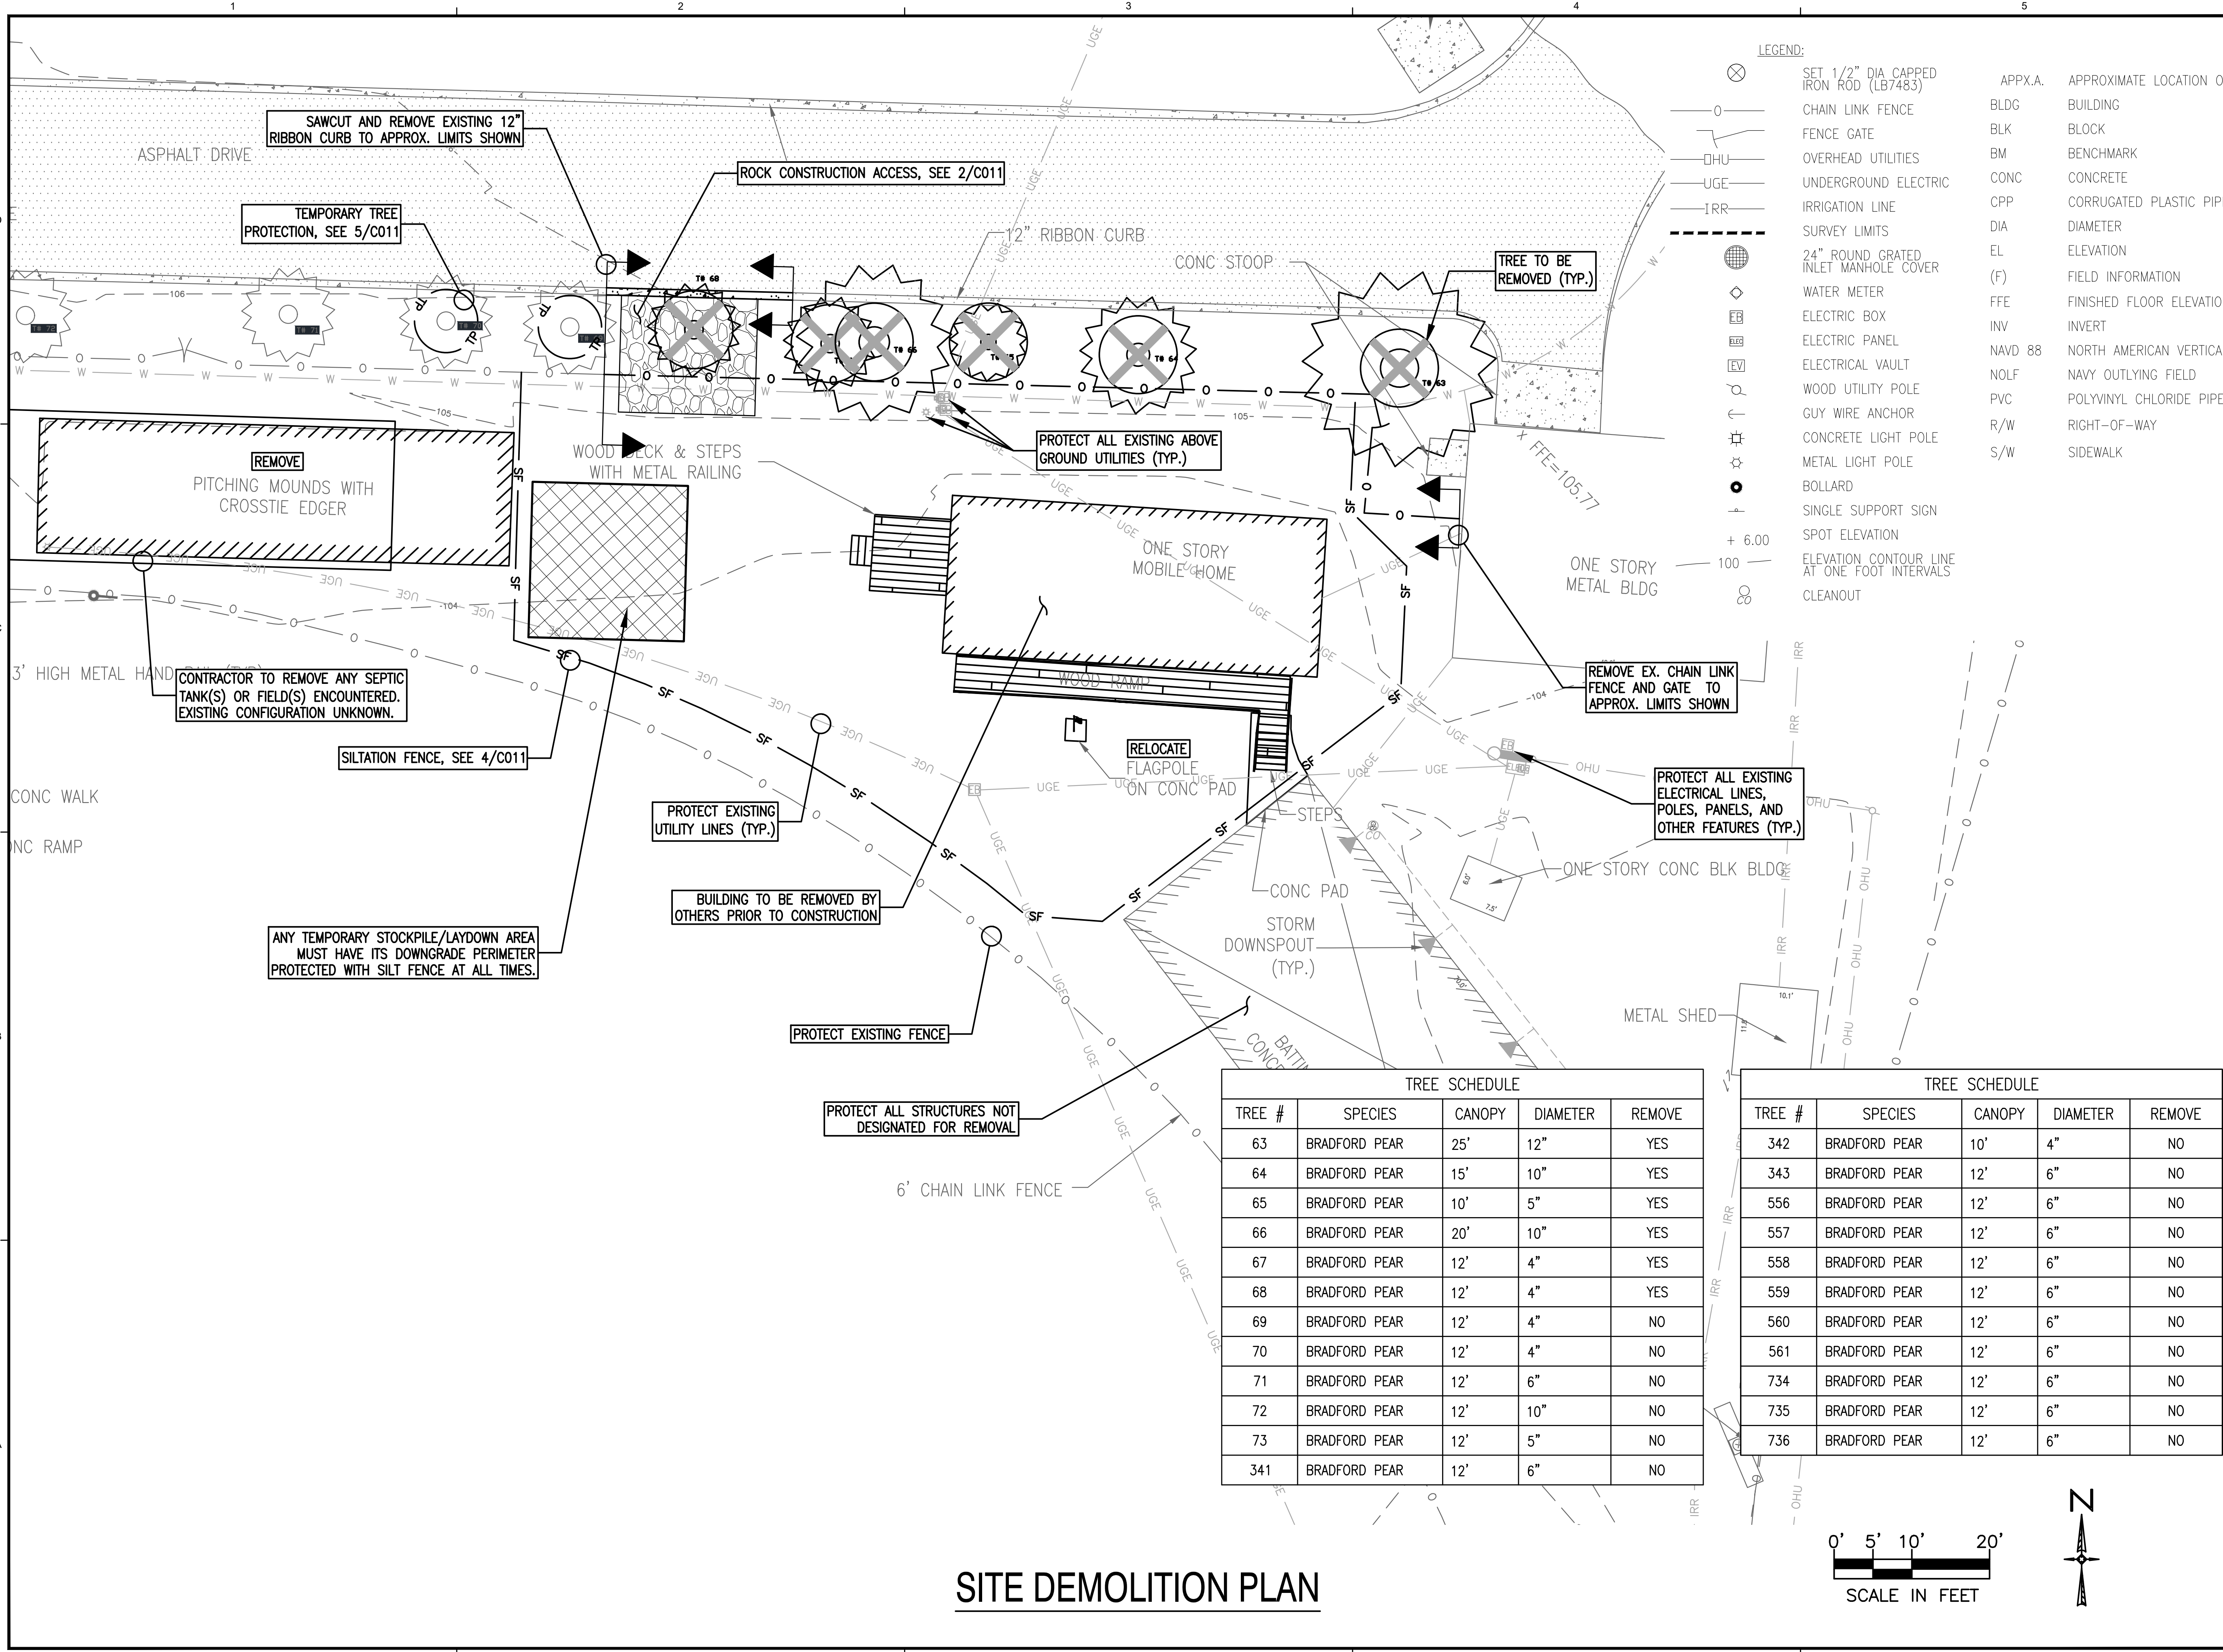

DAG ARCHITECTS INC.
40 S. PALAFOX PLACE - STE 201
PENSACOLA, FL 32502
TELEPHONE: 850-429-9004 FAX: 850-429-9005
AA-C000745

OWNERSHIP OF INSTRUMENTS OF SERVICE
ALL REPORTS, PLANS, SPECIFICATIONS, COMPUTER FILES, FIELD DATA,
NOTES AND OTHER DOCUMENTS AND INSTRUMENTS PREPARED BY
THE CONSULTANT AS INSTRUMENTS OF SERVICE SHALL REMAIN THE
PROPERTY OF THE CONSULTANT. THE CONSULTANT SHALL RETAIN ALL
COMMON LAW, STATUTORY AND OTHER RESERVED RIGHTS,
INCLUDING THE COPYRIGHT THEREON.


PHASE III DOCUMENTS

Pace High School Softball Fieldhouse

4065 Norris Rd.
Pace, FL 32571

TREE SCHEDULE				
TREE #	SPECIES	CANOPY	DIAMETER	REMOVE
63	BRADFORD PEAR	25'	12"	YES
64	BRADFORD PEAR	15'	10"	YES
65	BRADFORD PEAR	10'	5"	YES
66	BRADFORD PEAR	20'	10"	YES
67	BRADFORD PEAR	12'	4"	YES
68	BRADFORD PEAR	12'	4"	YES
69	BRADFORD PEAR	12'	4"	NO
70	BRADFORD PEAR	12'	4"	NO
71	BRADFORD PEAR	12'	6"	NO
72	BRADFORD PEAR	12'	10"	NO
73	BRADFORD PEAR	12'	5"	NO
341	BRADFORD PEAR	12'	6"	NO

TREE SCHEDULE				
TREE #	SPECIES	CANOPY	DIAMETER	REMOVE
342	BRADFORD PEAR	10'	4"	NO
343	BRADFORD PEAR	12'	6"	NO
556	BRADFORD PEAR	12'	6"	NO
557	BRADFORD PEAR	12'	6"	NO
558	BRADFORD PEAR	12'	6"	NO
559	BRADFORD PEAR	12'	6"	NO
560	BRADFORD PEAR	12'	6"	NO
561	BRADFORD PEAR	12'	6"	NO
734	BRADFORD PEAR	12'	6"	NO
735	BRADFORD PEAR	12'	6"	NO
736	BRADFORD PEAR	12'	6"	NO

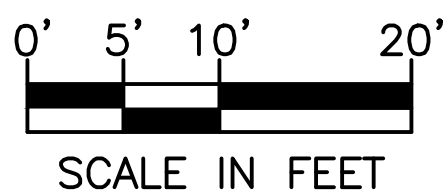

Revision		
Date:	No.	Description:


Drawn By:
Checked By:

Date: 11-29-18

Project No.: 180040

Drawing Title:
**SITE
DEMOLITION
PLAN**

Drawing No.:
C002

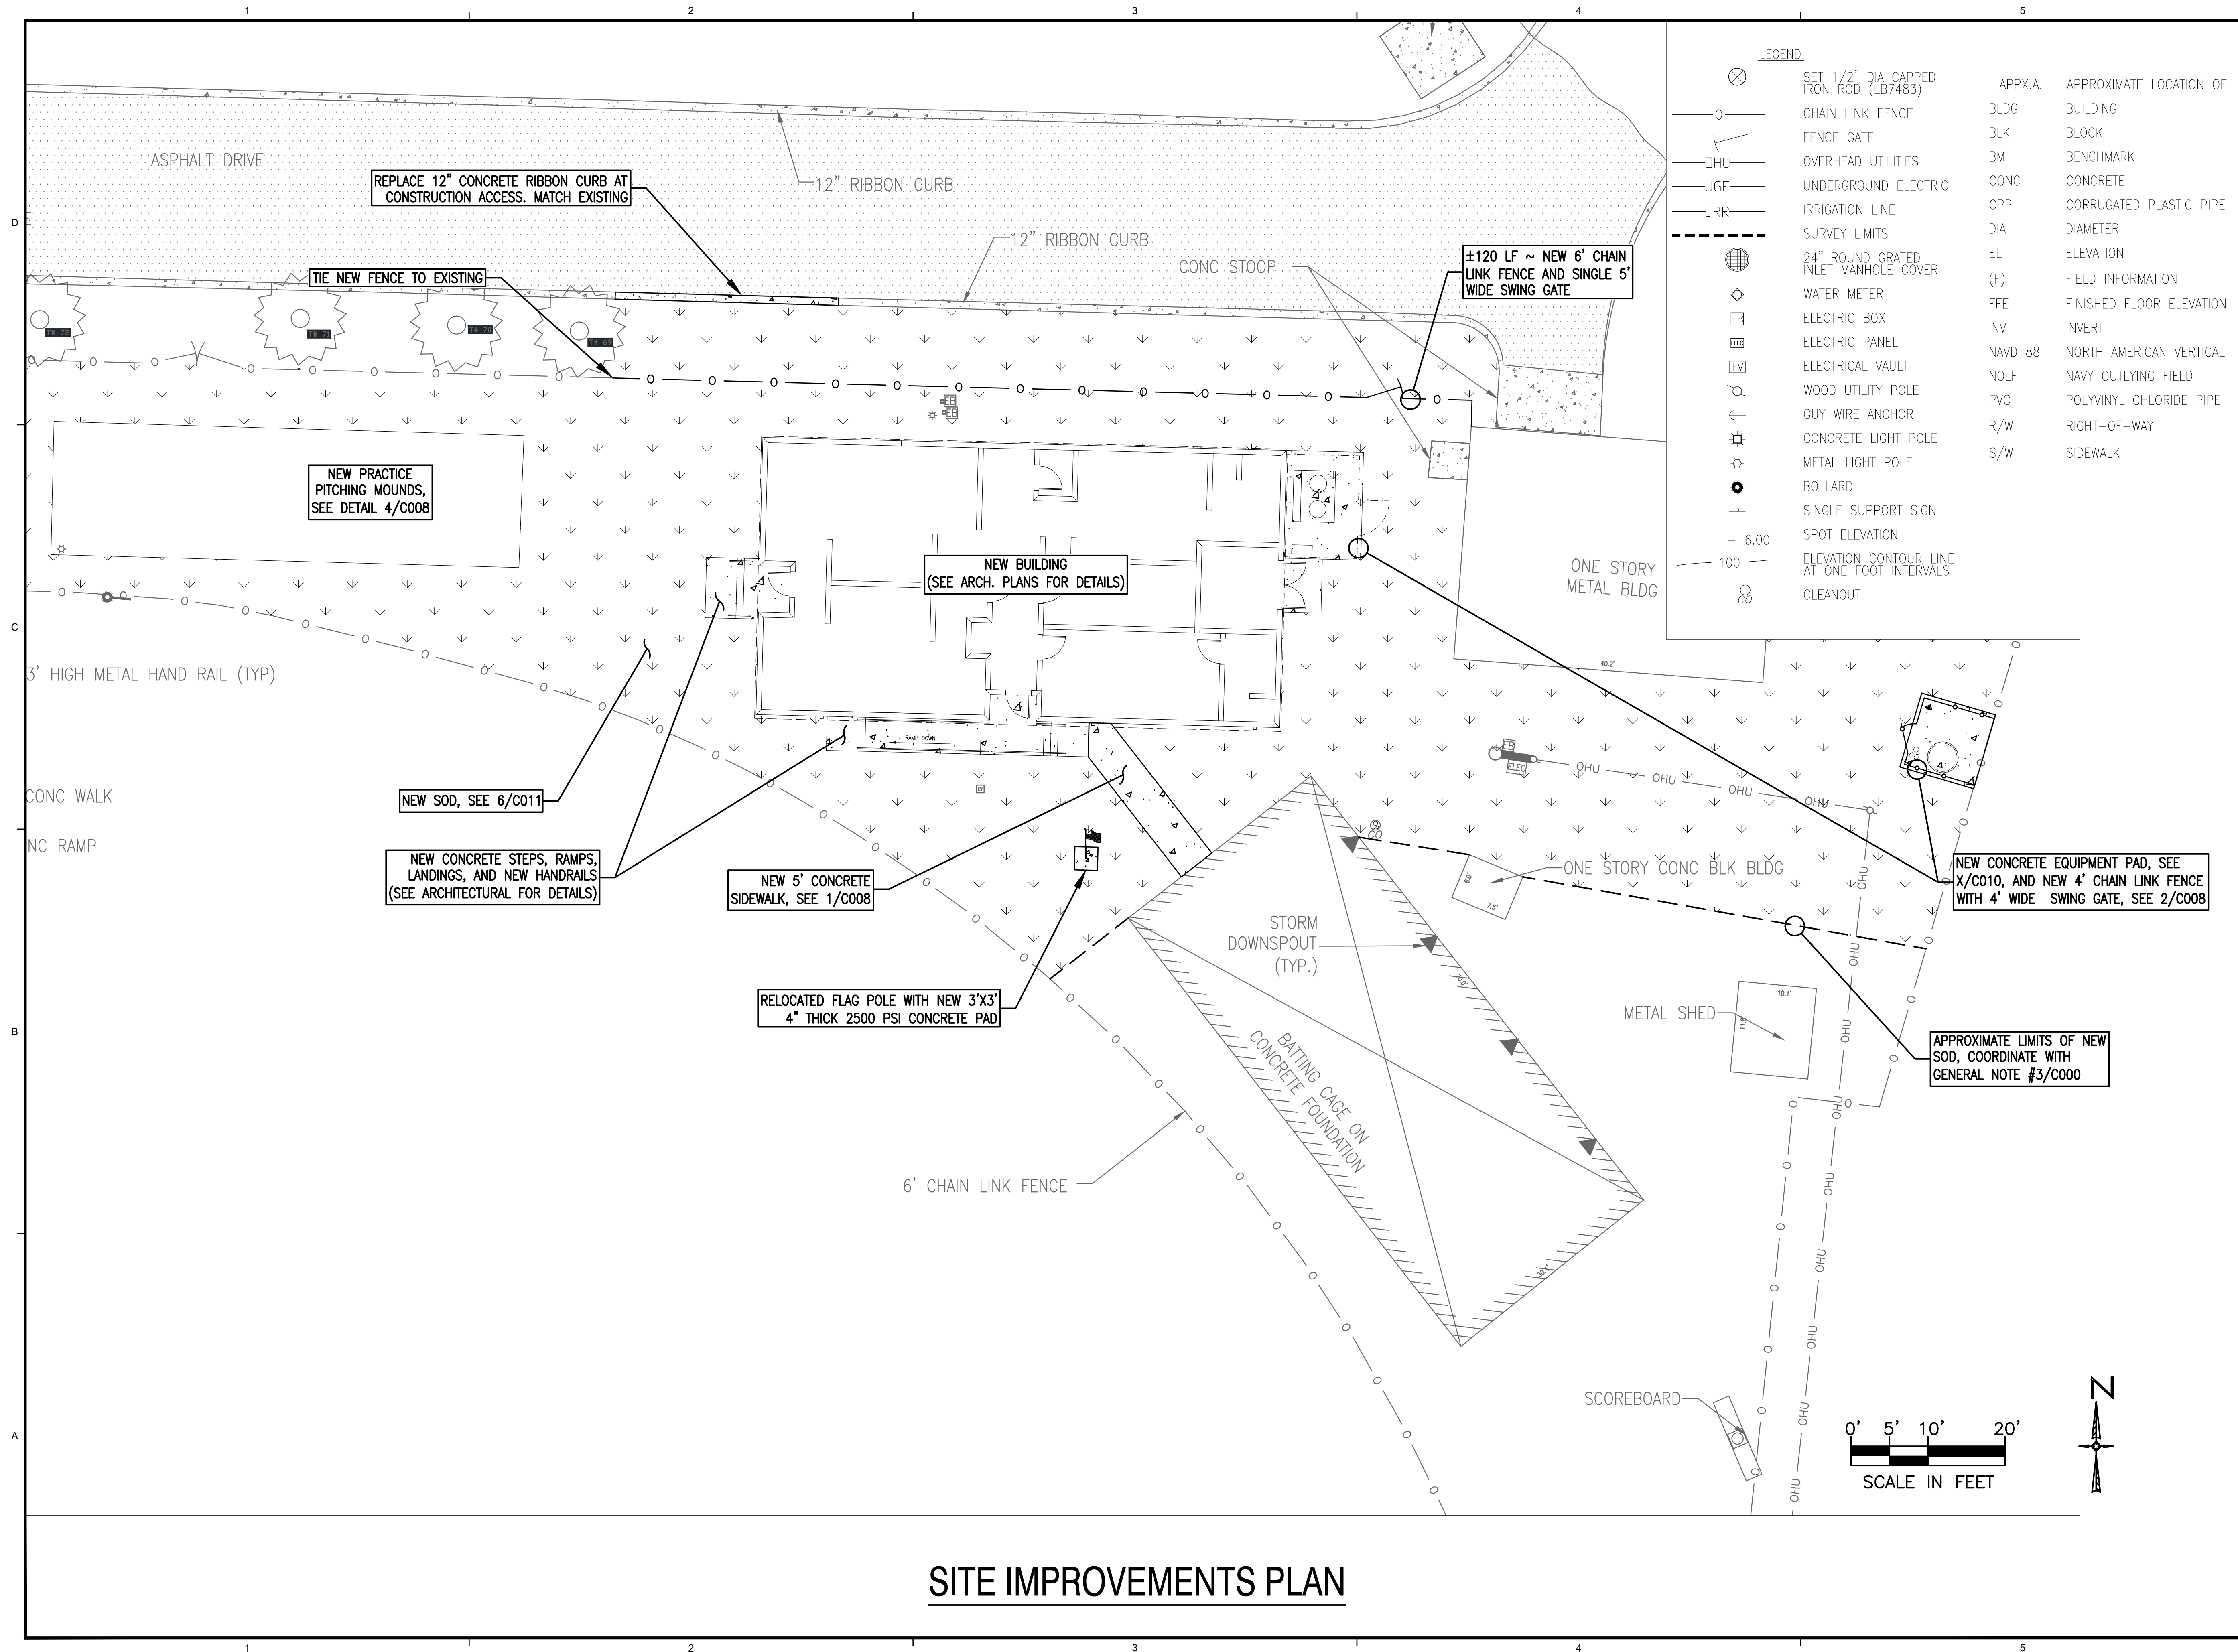

DAG ARCHITECTS INC.
40 S. PALAFOX PLACE - STE 201
PENSACOLA, FL 32502
TELEPHONE: 850-429-9004 FAX: 850-429-9005
AA-C000745

OWNERSHIP OF INSTRUMENTS OF SERVICE
ALL REPORTS, PLANS, SPECIFICATIONS, COMPUTER FILES, FIELD DATA, NOTES AND OTHER DOCUMENTS AND INSTRUMENTS PREPARED BY THE CONSULTANT AS INSTRUMENTS OF SERVICE SHALL REMAIN THE PROPERTY OF THE CONSULTANT. THE CONSULTANT SHALL RETAIN ALL COMMON LAW, STATUTORY AND OTHER RESERVED RIGHTS, INCLUDING THE COPYRIGHT THERE TO.

PHASE III
DOCUMENTS

Pace High School Softball Fieldhouse

4065 Norris Rd.
Pace, FL 32571

[illegible]

Drawn By:
Checked By:


Date: 11-29-18

Project No.: 180040

Drawing Title:

**SITE
IMPROVEMENTS
PLAN**

Drawing No.: **C003**

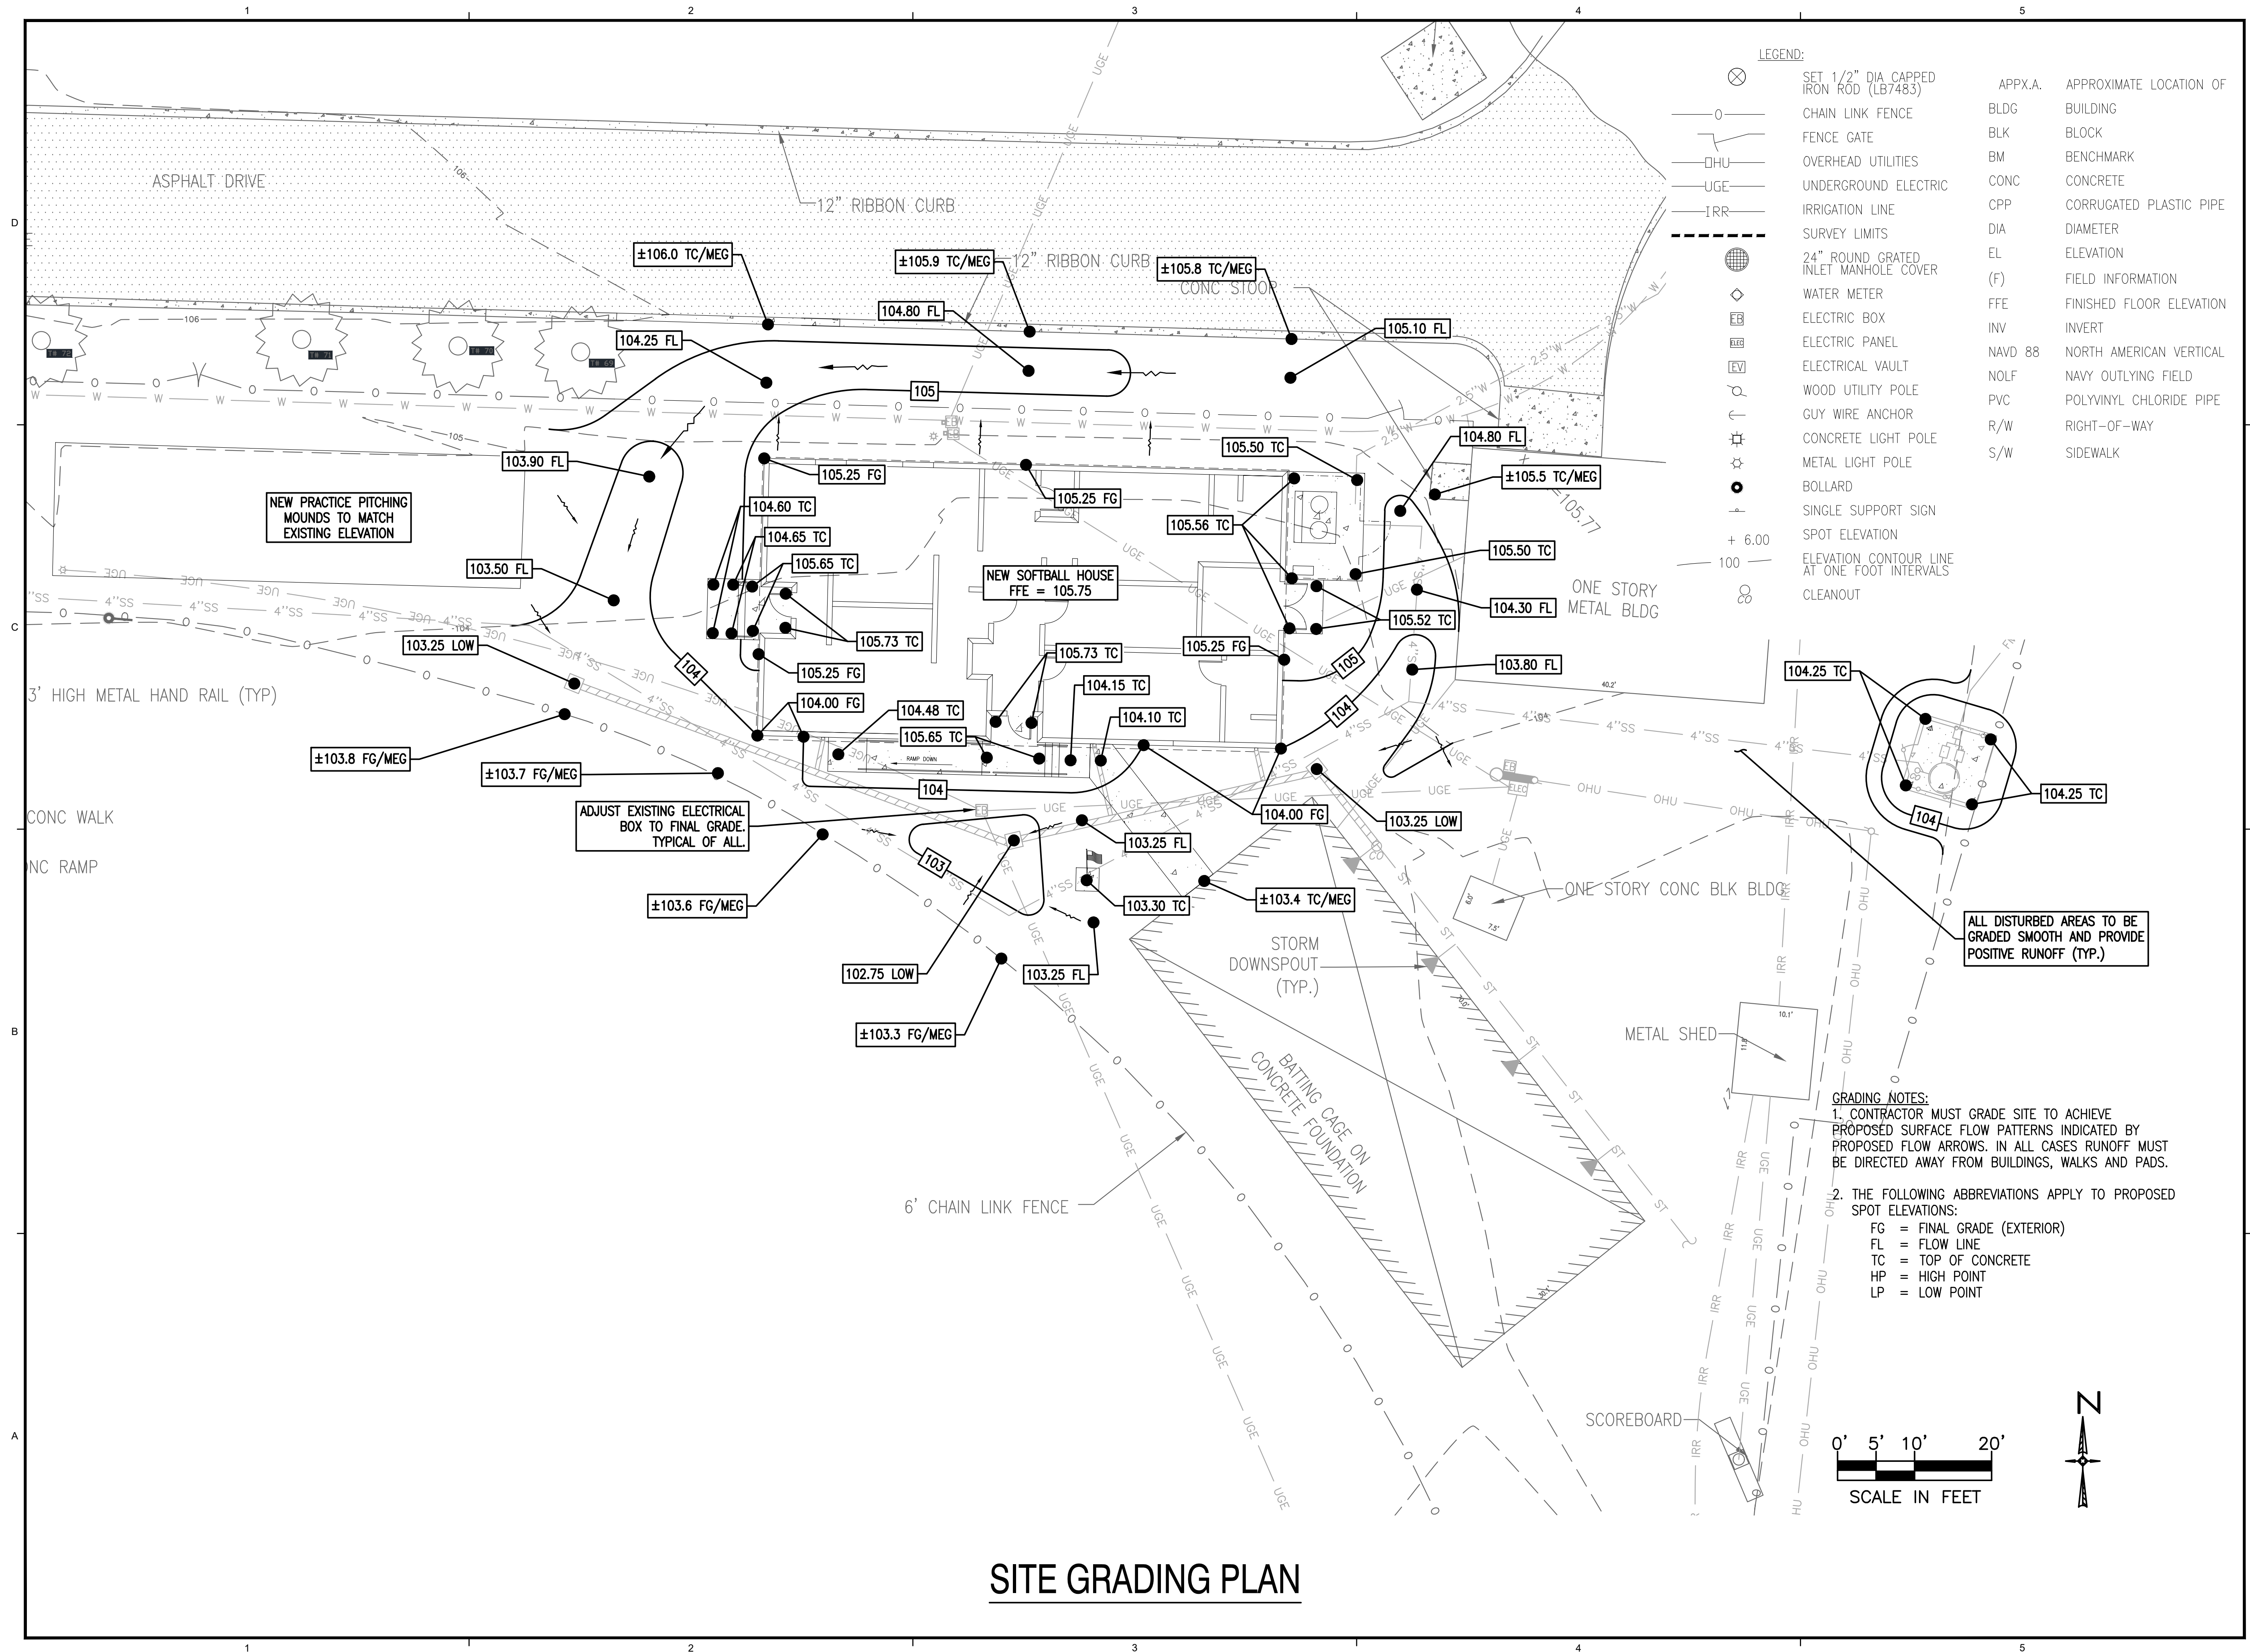

DAG ARCHITECTS INC.
 10 S. PALAFOX PLACE - STE 201
 GAITHERSBURG, MD 20878
 TELEPHONE: 855-429-9004 FAX: 855-429-9005
 E-MAIL: info@dagarchitects.com
 AIA-C000745

OWNERSHIP OF INSTRUMENTS OF SERVICE
 L REPORTS, PLANS, SPECIFICATIONS, COMPUTER FILES, FIELD DATA, NOTES AND OTHER DOCUMENTS AND INSTRUMENTS PREPARED BY THE CONSULTANT AS INSTRUMENTS OF SERVICE SHALL REMAIN THE PROPERTY OF THE CONSULTANT. THE CONSULTANT SHALL RETAIN ALL COMMON LAW, STATUTORY AND OTHER RESERVED RIGHTS, INCLUDING THE COPYRIGHT THERETO.

PHASE III
DOCUMENTS

Pace High School Softball Fieldhouse

4065 Norris Rd.

4065 Norris Rd.
Pace, FL 32571

[illegible]

Drawn By:
Checked By:

Date: 11-29-18


Project No.: 180040

Drawing Title:

SITE GRADING PLAN

Drawing No.: 0

C005

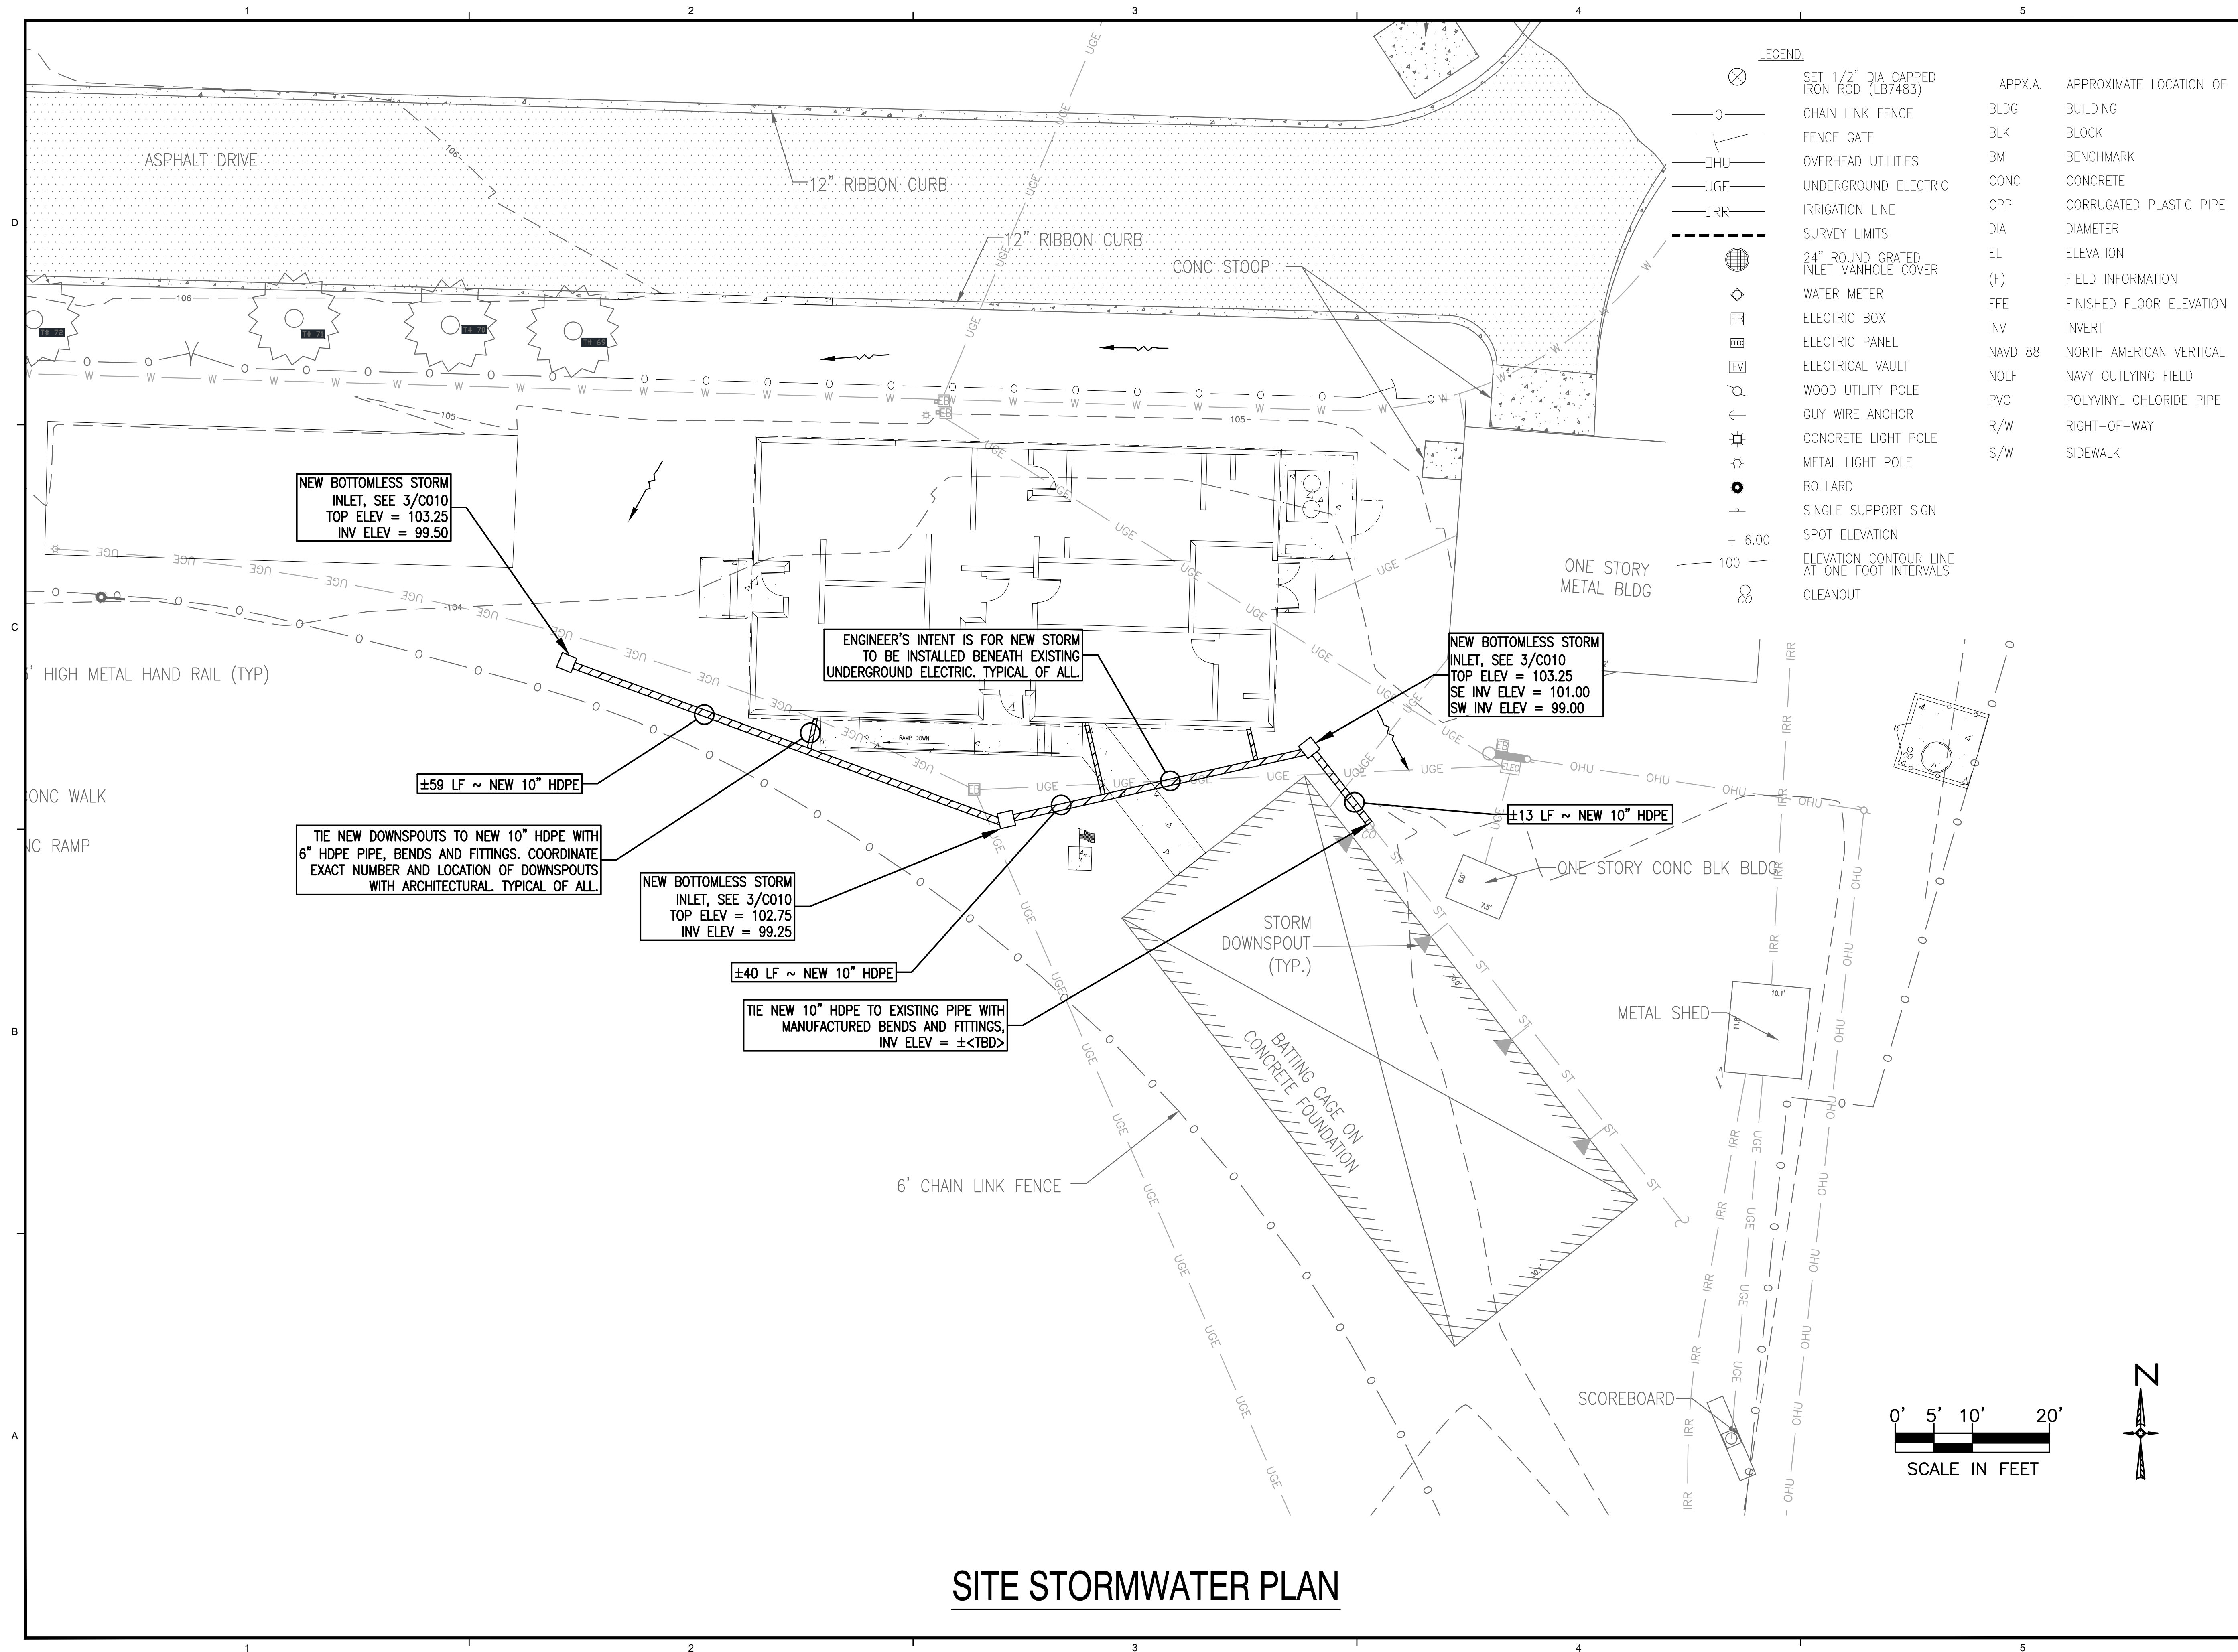

DAG ARCHITECTS INC.
40 S. PALAFOX PLACE - STE 201
PENSACOLA, FL 32502
TELEPHONE: 850-429-9004 FAX: 850-429-9005
AA-C000745

OWNERSHIP OF INSTRUMENTS OF SERVICE
ALL REPORTS, PLANS, SPECIFICATIONS, COMPUTER FILES, FIELD DATA, NOTES AND OTHER DOCUMENTS AND INSTRUMENTS PREPARED BY THE CONSULTANT AS INSTRUMENTS OF SERVICE SHALL REMAIN THE PROPERTY OF THE CONSULTANT. THE CONSULTANT SHALL RETAIN ALL COMMON LAW, STATUTORY AND OTHER RESERVED RIGHTS, INCLUDING THE COPYRIGHT THERE TO.

PHASE III
DOCUMENTS

Pace High School Softball Fieldhouse

4065 Norris Rd.
Pace, FL 32571

[illegible]

Drawn By:
Checked By:


Date: 11-29-18

Project No.: 180040

Drawing Title:

**SITE
STORMWATER
PLAN**

Drawing No.: **C006**

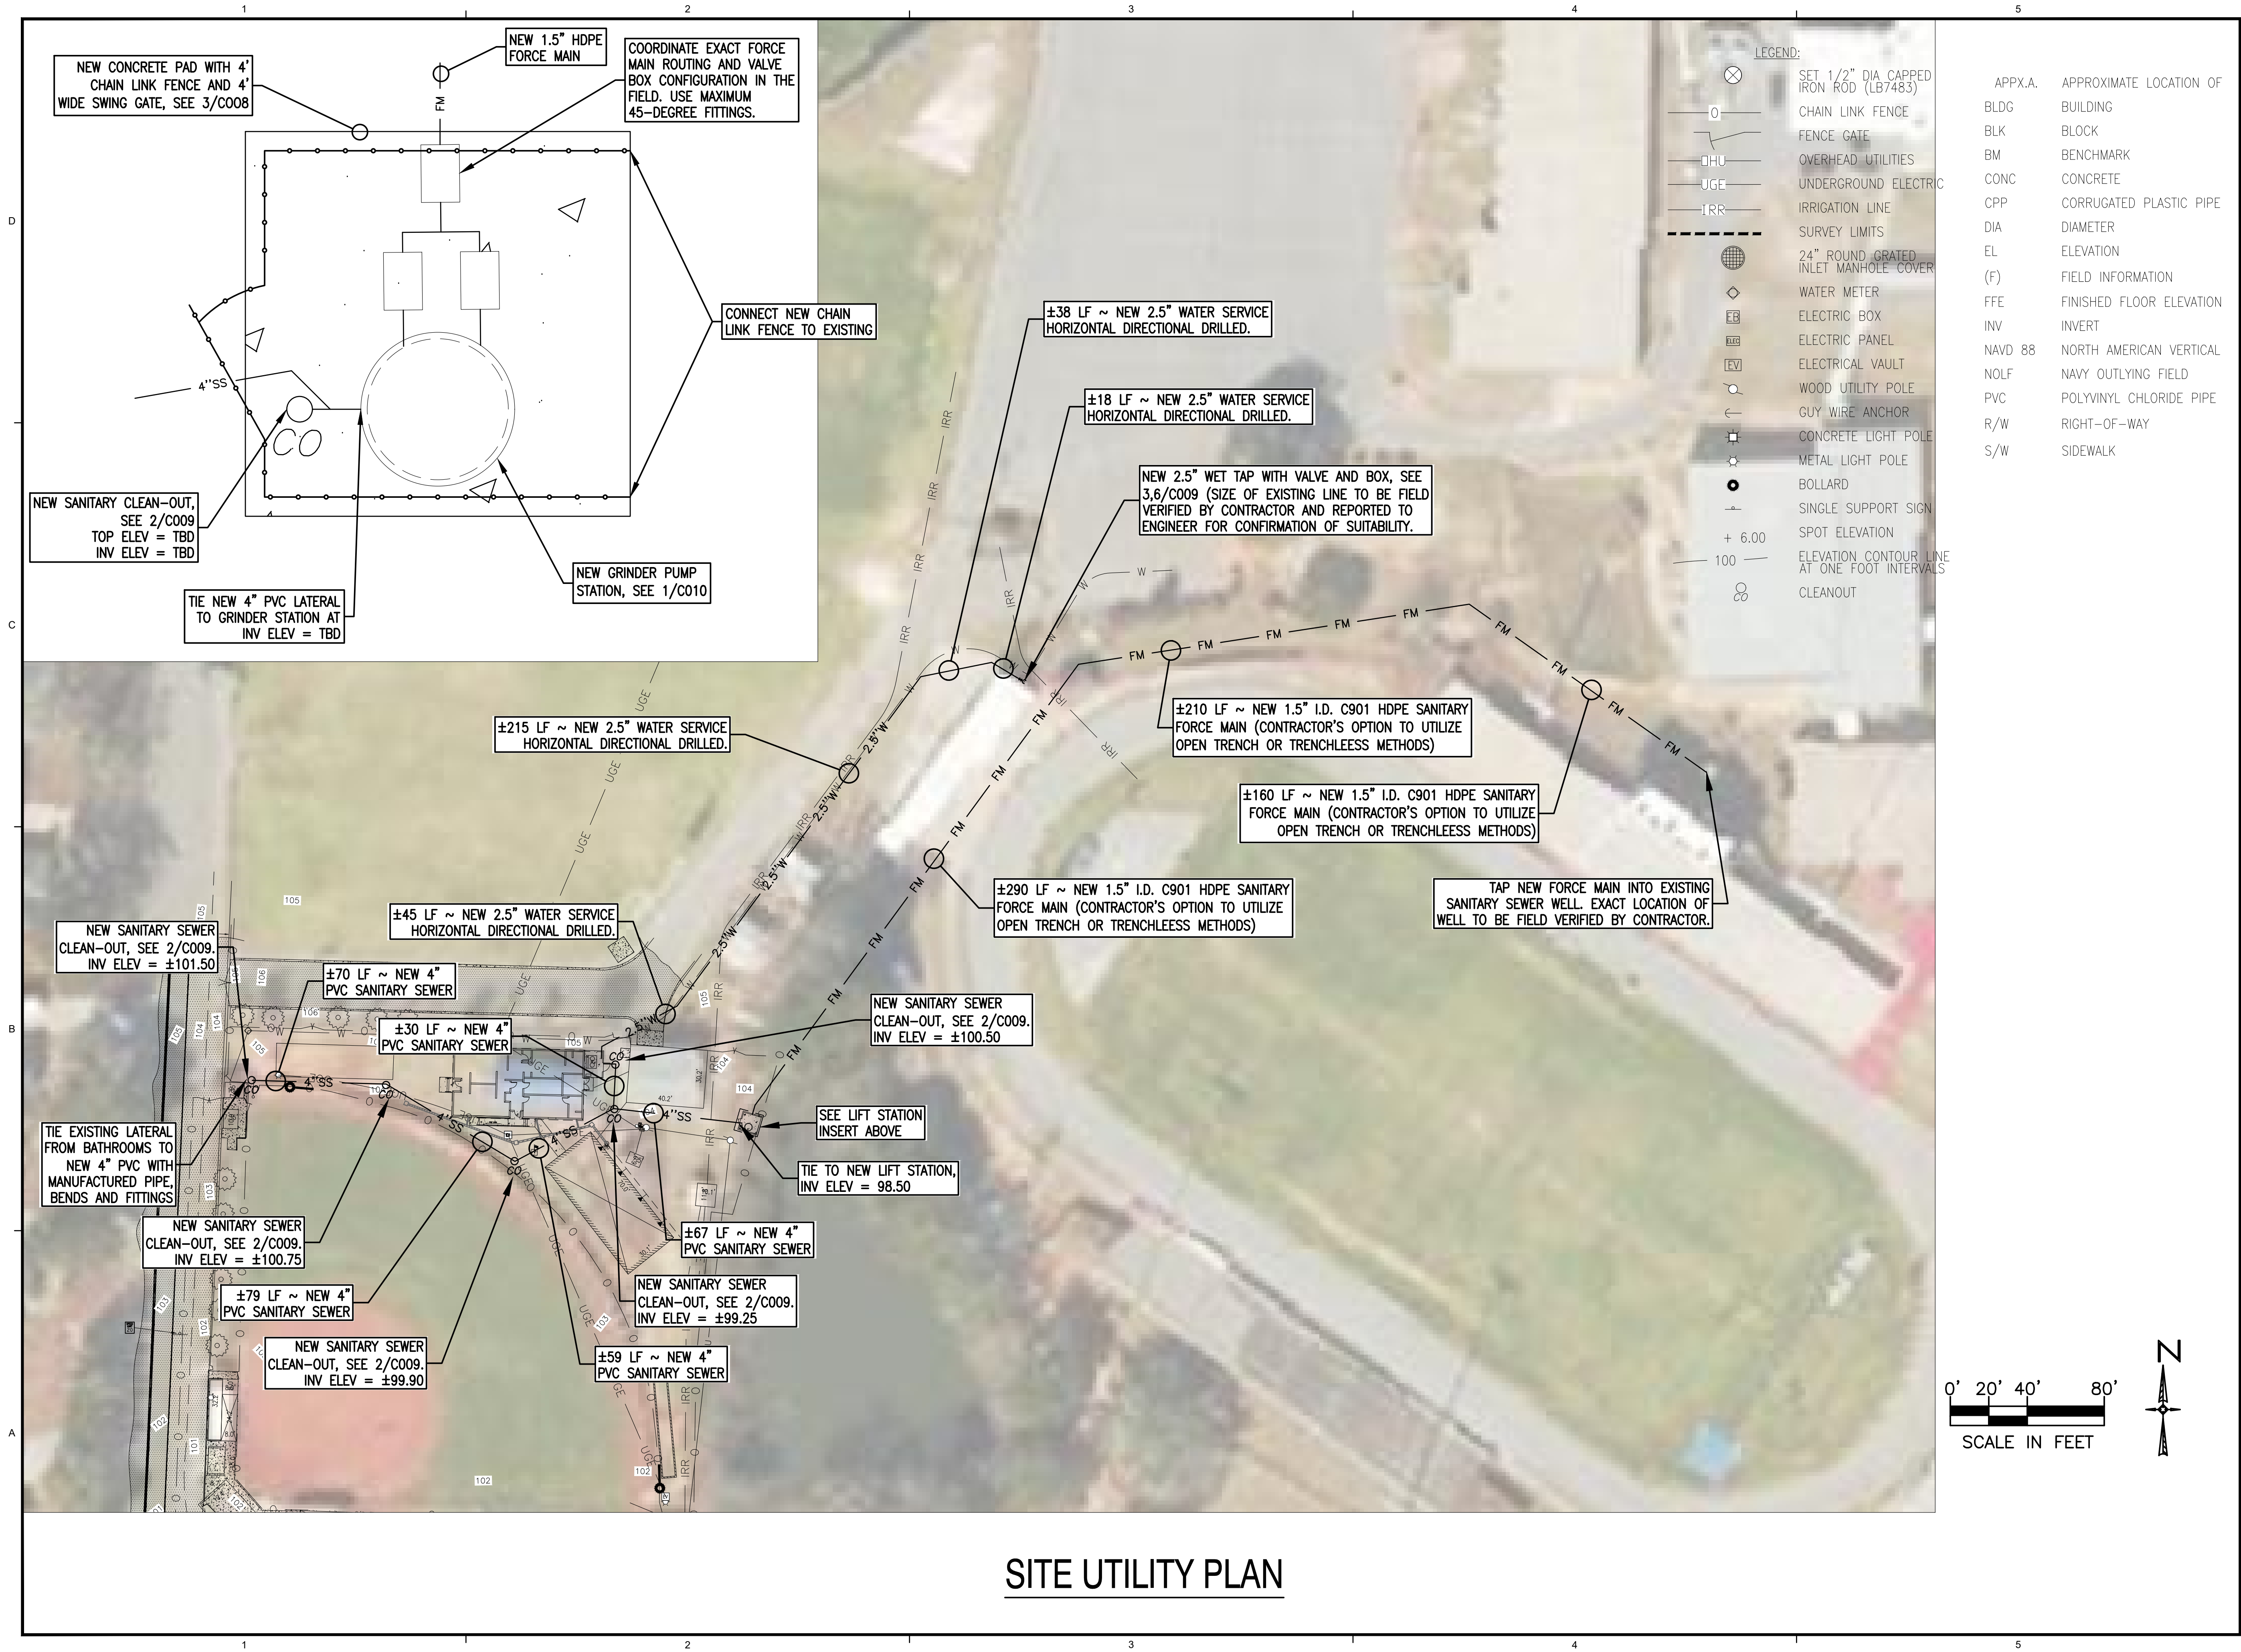

SITE UTILITY PLAN

OWNERSHIP OF INSTRUMENTS OF SERVICE
ALL REPORTS, PLANS, SPECIFICATIONS, COMPUTER FILES, FIELD DATA NOTES AND OTHER DOCUMENTS AND INSTRUMENTS PREPARED BY THE CONSULTANT AS INSTRUMENTS OF SERVICE SHALL REMAIN THE PROPERTY OF THE CONSULTANT. THE CONSULTANT SHALL RETAIN ALL COMMON LAW, STATUTORY AND OTHER RESERVED RIGHTS, INCLUDING THE COPYRIGHT THERETO.

PHASE III
DOCUMENTS

Pace High School Softball Fieldhouse

[illegible]

Drawn By: SWL
Checked By: BLSE


Date: 11-29-18


Project No.: 18045

Drawing Title:

FOUNDATION PLAN
SECTIONS AND DETAILS

Drawing No.: **S101**

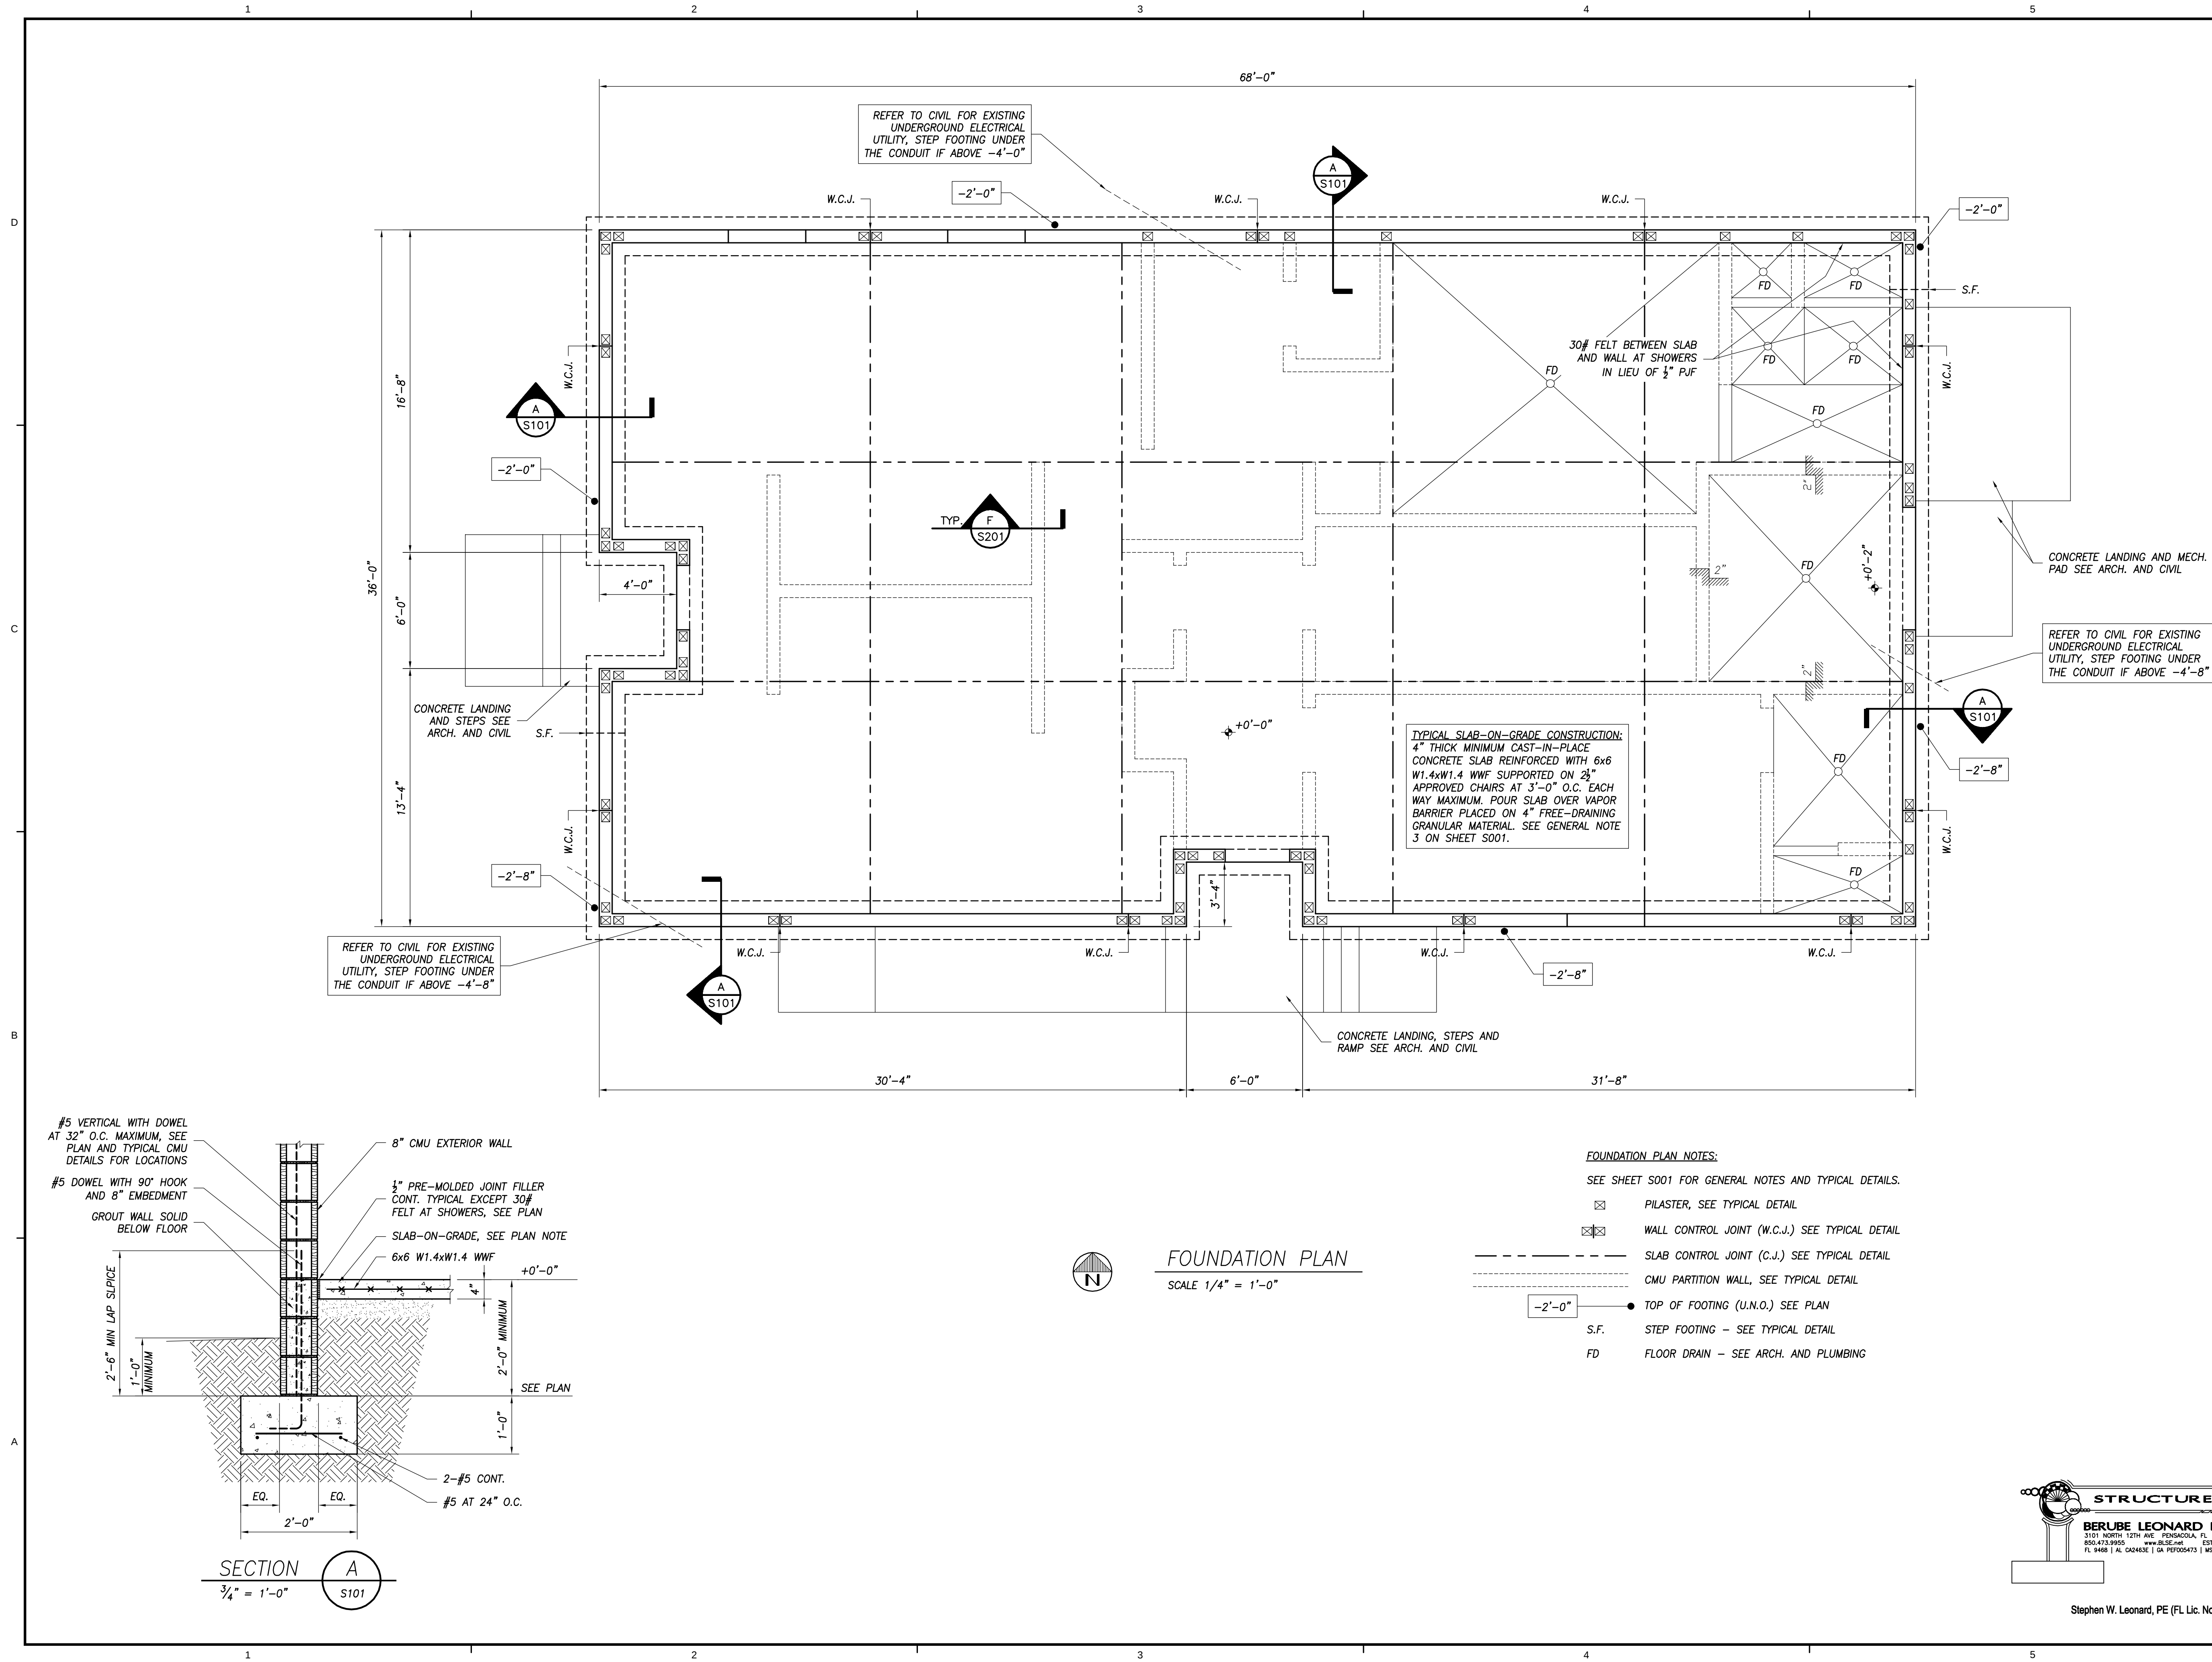

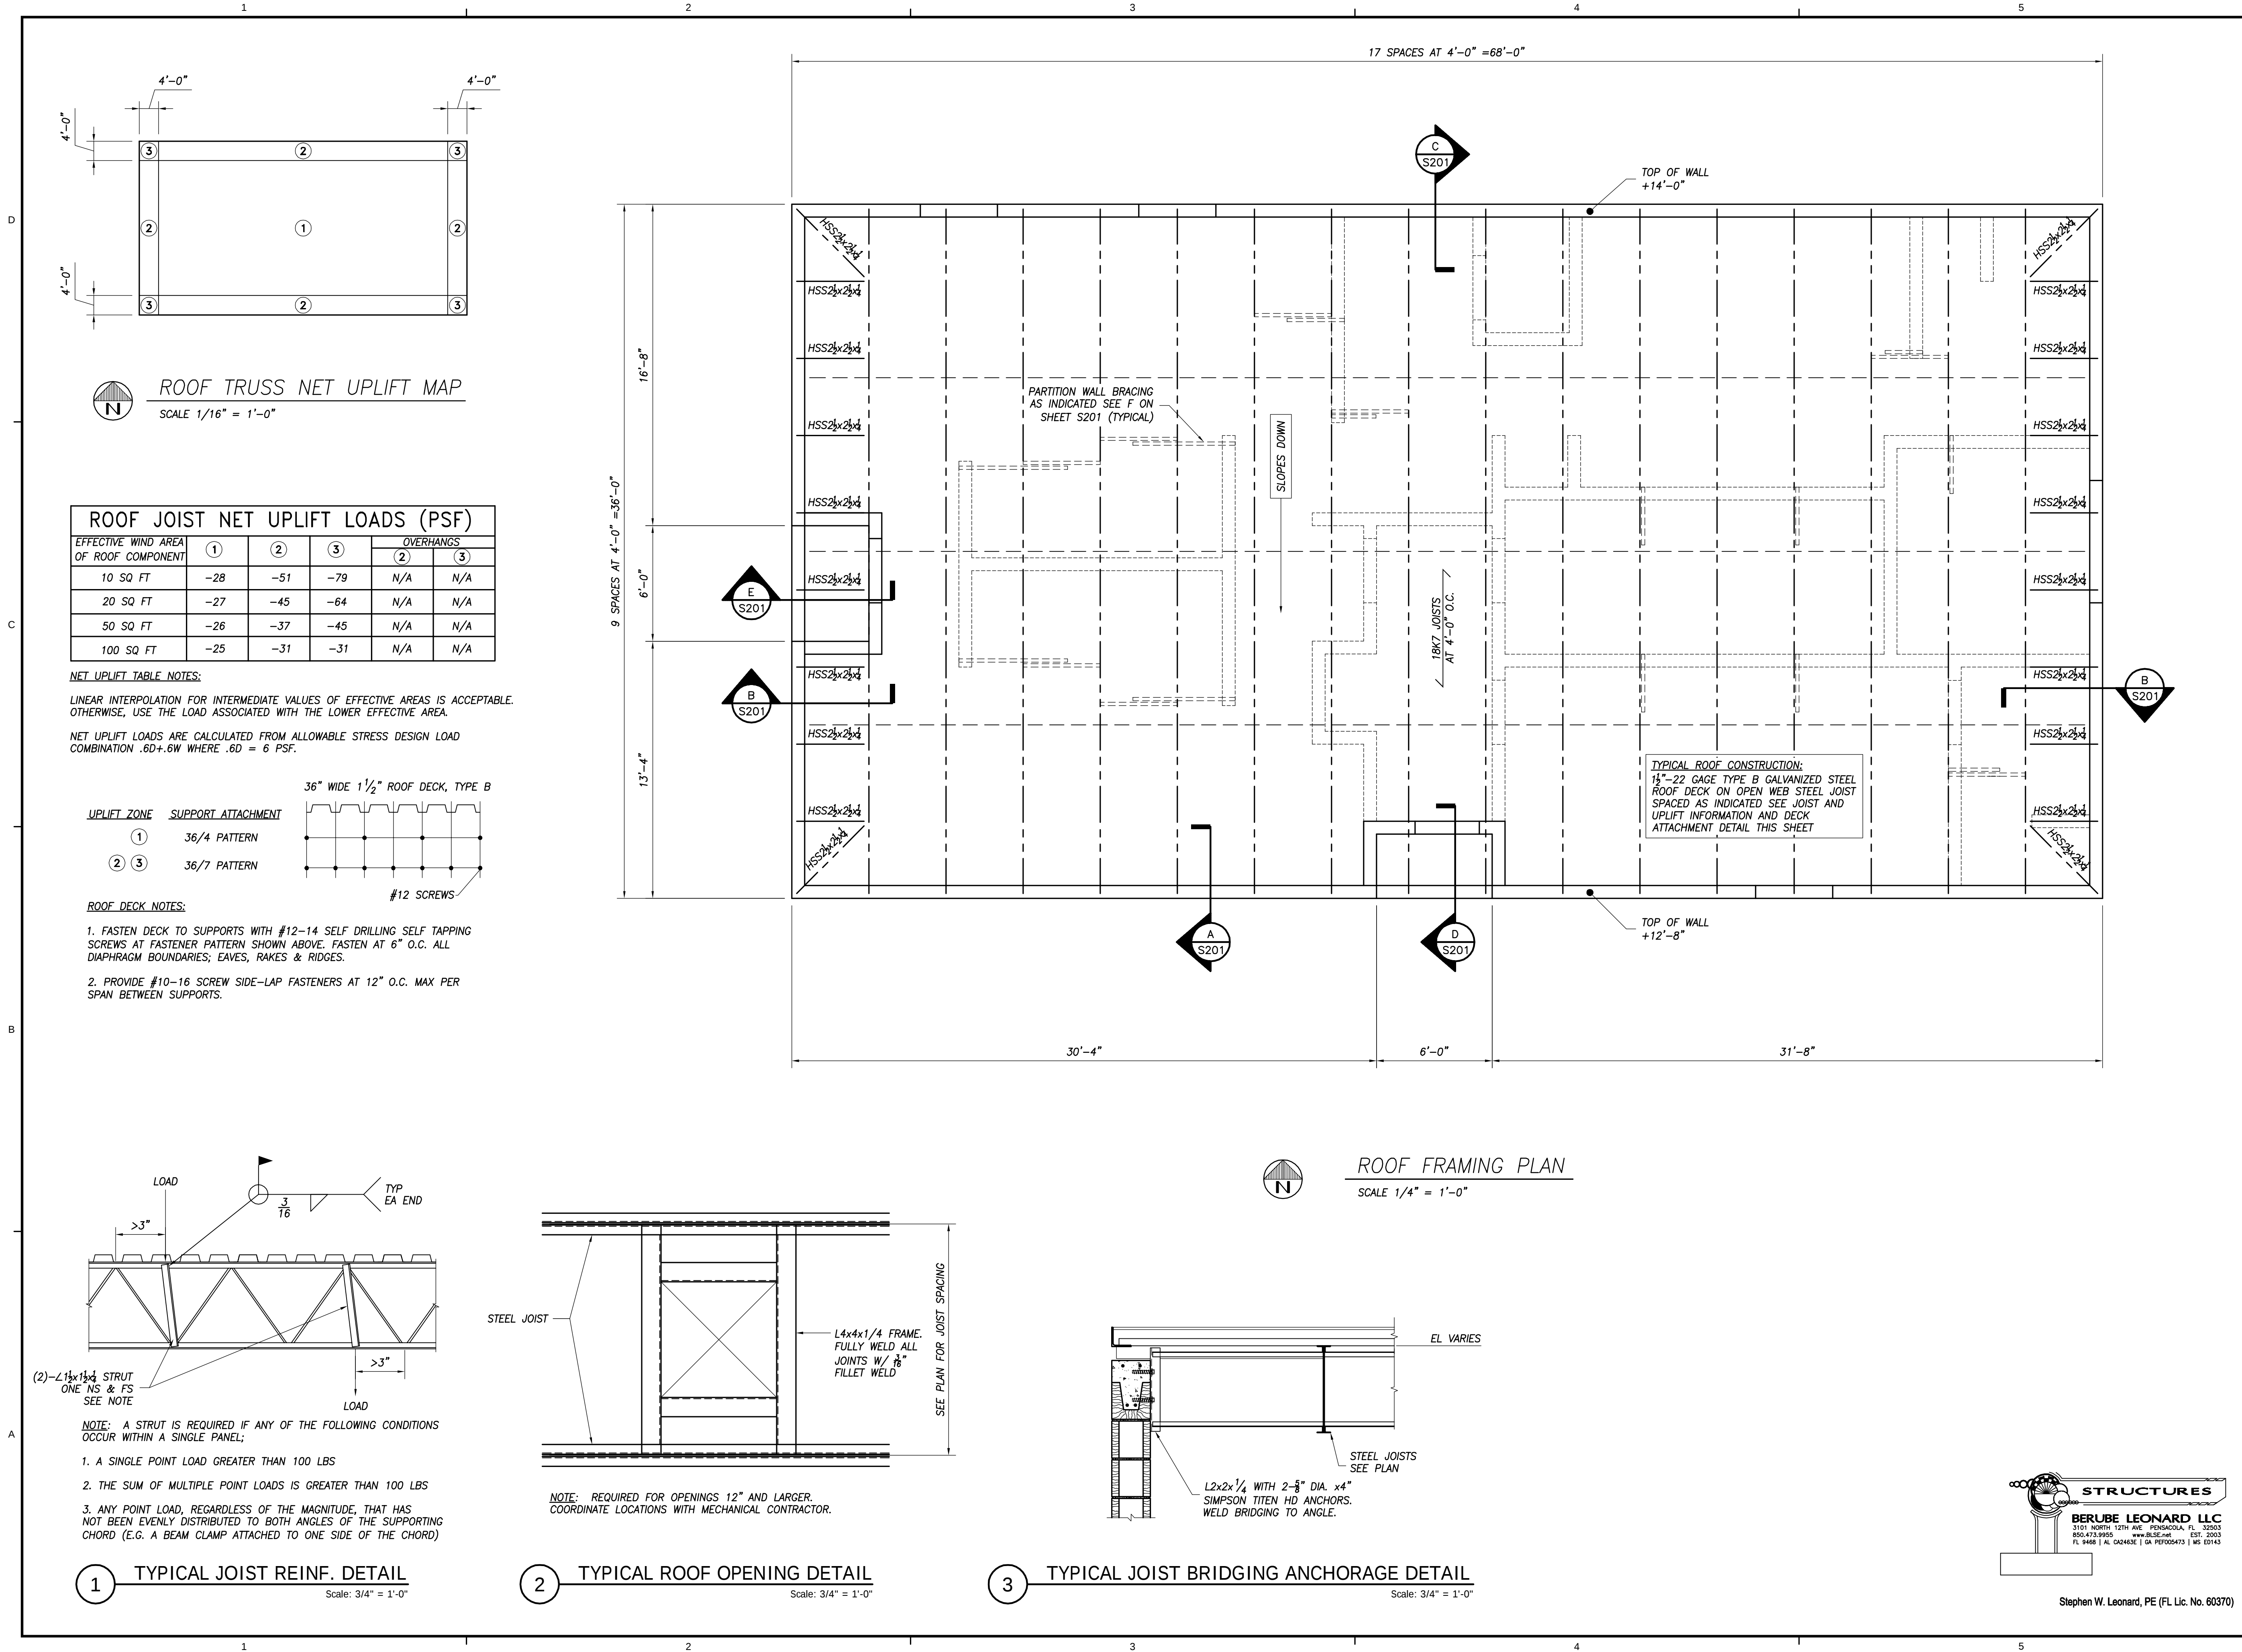

DAG ARCHITECTS INC.
40 S. PALAFOX PLACE - STE 201
PENSACOLA, FL 32502
TELEPHONE: 850-429-9004 FAX: 850-429-9005
AA-C000745

OWNERSHIP OF INSTRUMENTS OF SERVICE
ALL REPORTS, PLANS, SPECIFICATIONS, COMPUTER FILES, FIELD DATA, NOTES AND OTHER DOCUMENTS AND INSTRUMENTS PREPARED BY THE CONSULTANT AS INSTRUMENTS OF SERVICE SHALL REMAIN THE PROPERTY OF THE CONSULTANT. THE CONSULTANT SHALL RETAIN ALL COMMON LAW, STATUTORY AND OTHER RESERVED RIGHTS, INCLUDING THE COPYRIGHT THERETO.

PHASE III DOCUMENTS

Pace High School Softball Fieldhouse

4065 Norris Rd.
Pace, FL 32571

Revision

Date:	No.	Description:
-	-	-
-	-	-
Drawn By: SWL
Checked By: BLSE

Date: 11-29-18

Project No.: 18045

Drawing Title:
ROOF FRAMING PLAN
TYPICAL JOIST AND
DECK DETAILS

Drawing No.: S102

OWNERSHIP OF INSTRUMENTS OF SERVICE
ALL REPORTS, PLANS, SPECIFICATIONS, COMPUTER FILES, FIELD DATA, NOTES AND OTHER DOCUMENTS AND INSTRUMENTS PREPARED BY THE CONSULTANT AS INSTRUMENTS OF SERVICE SHALL REMAIN THE PROPERTY OF THE CONSULTANT. THE CONSULTANT SHALL RETAIN ALL COMMON LAW, STATUTORY AND OTHER RESERVED RIGHTS, INCLUDING THE COPYRIGHT THERETO.

PHASE III
DOCUMENTS

Pace High School Softball Fieldhouse

[illegible]

Drawn By: SJT
Checked By: DAG

Date: 11-29-18

Project No.: 18045

Drawing Title:
FLOOR PLAN


Drawing No.:

A101

- ① CONCRETE STAIR AND LANDINGS, SEE DETAILS.
- ② CONCRETE RAMP AND LANDINGS, SEE DETAILS.
- ③ PAINTED METAL HANDRAILS, SEE DETAILS.
- ④ CONCRETE LANDING, REFER TO CIVIL DRAWINGS FOR
TYPICAL DETAIL. SLOPE TO DRAIN AROUND
BUILDING.
- ⑤ 4" THICK CONCRETE PAD WITH 8" x 8" TURN DOWN
EDGE W/ 2-#5 CONT. 4" HIGH CHAIN LINK FENCE
WITH 4" WIDE SWING GATE AROUND MECHANICAL YARD.
SIDEWALK STEPS DOWN -2' AT MECH. YARDS.
- ⑥ FLOOR SLOPES TO FLOOR DRAIN. COORDINATE WITH
EQUIPMENT PADS, SEE MECHANICAL. SLAB IS
RECESSED 2" IN MECH. ROOMS. SEE STRUCTURAL.
- ⑦ FLOOR SLOPES TO FLOOR DRAIN. COORDINATE
FLOORING THICKNESS WITH FLOOR DRAIN INSTALLATION,
SEE DETAIL.
- ⑧ MOP SHELF, SEE TOILET ACCESSORY SCHEDULE,
SHEET A601
- ⑨ METAL SHELVING UNIT, SEE SPECIFICATIONS
- ⑩ SHOWER ROD AND CURTAIN, TYP. SEE TOILET
ACCESSORY SCHEDULE, SHEET A601
- ⑪ CLOSET ROD AND WIRE SHELF SYSTEM
- ⑫ FULL LENGTH MIRROR, SEE TOILET ACCESSORY
SCHEDULE, SHEET A601
- ⑬ OWNER PROVIDED EQUIPMENT
- ⑭ STANDARD 2 TIER PLASTIC LOCKERS, 72"H X 18"W X
18"D, SEE SPECIFICATIONS, ON MANUFACTURER HDPE
BASE
- ⑮ FULL HEIGHT ATHLETIC LOCKERS 72"H X 24" W X
24"D, SEE SPECIFICATIONS, ON MANUFACTURER HDPE
BASE
- ⑯ DOWNSPOUT, TYP. OF 3, SEE ROOF PLAN AND DETAILS

1. SEAL WALL JOINTS AND AT THE ROOF DECK TO ENSURE ACOUSTICAL INTEGRITY (ALL WALLS) AND FIRE RATING (WHERE REQUIRED).
2. BRACE ALL CMU WALLS THAT TERMINATE AT 9'-4" A.F.F. AS INDICATED ON STRUCTURAL DRAWINGS.
3. STENCIL ABOVE CEILING ON BOTH SIDES OF ALL FIRE RATED WALLS 3" HIGH LETTERING TO READ "FIRE BARRIER- PROTECT ALL OPENINGS".

	1 HOUR RATED FIRE BARRIER WALL
	UL DESIGNS: <u>U905</u> (CMU) OR EQUIV.
	THICKNESS 8"
	CMU PER FBC TABLE 721.1
	(2) #3
	8" CMU WALLS, SEE WALL TYPES SHEET A310
	AND SECTIONS FOR MORE INFORMATION
	FIRE EXTINGUISHER AND CABINET

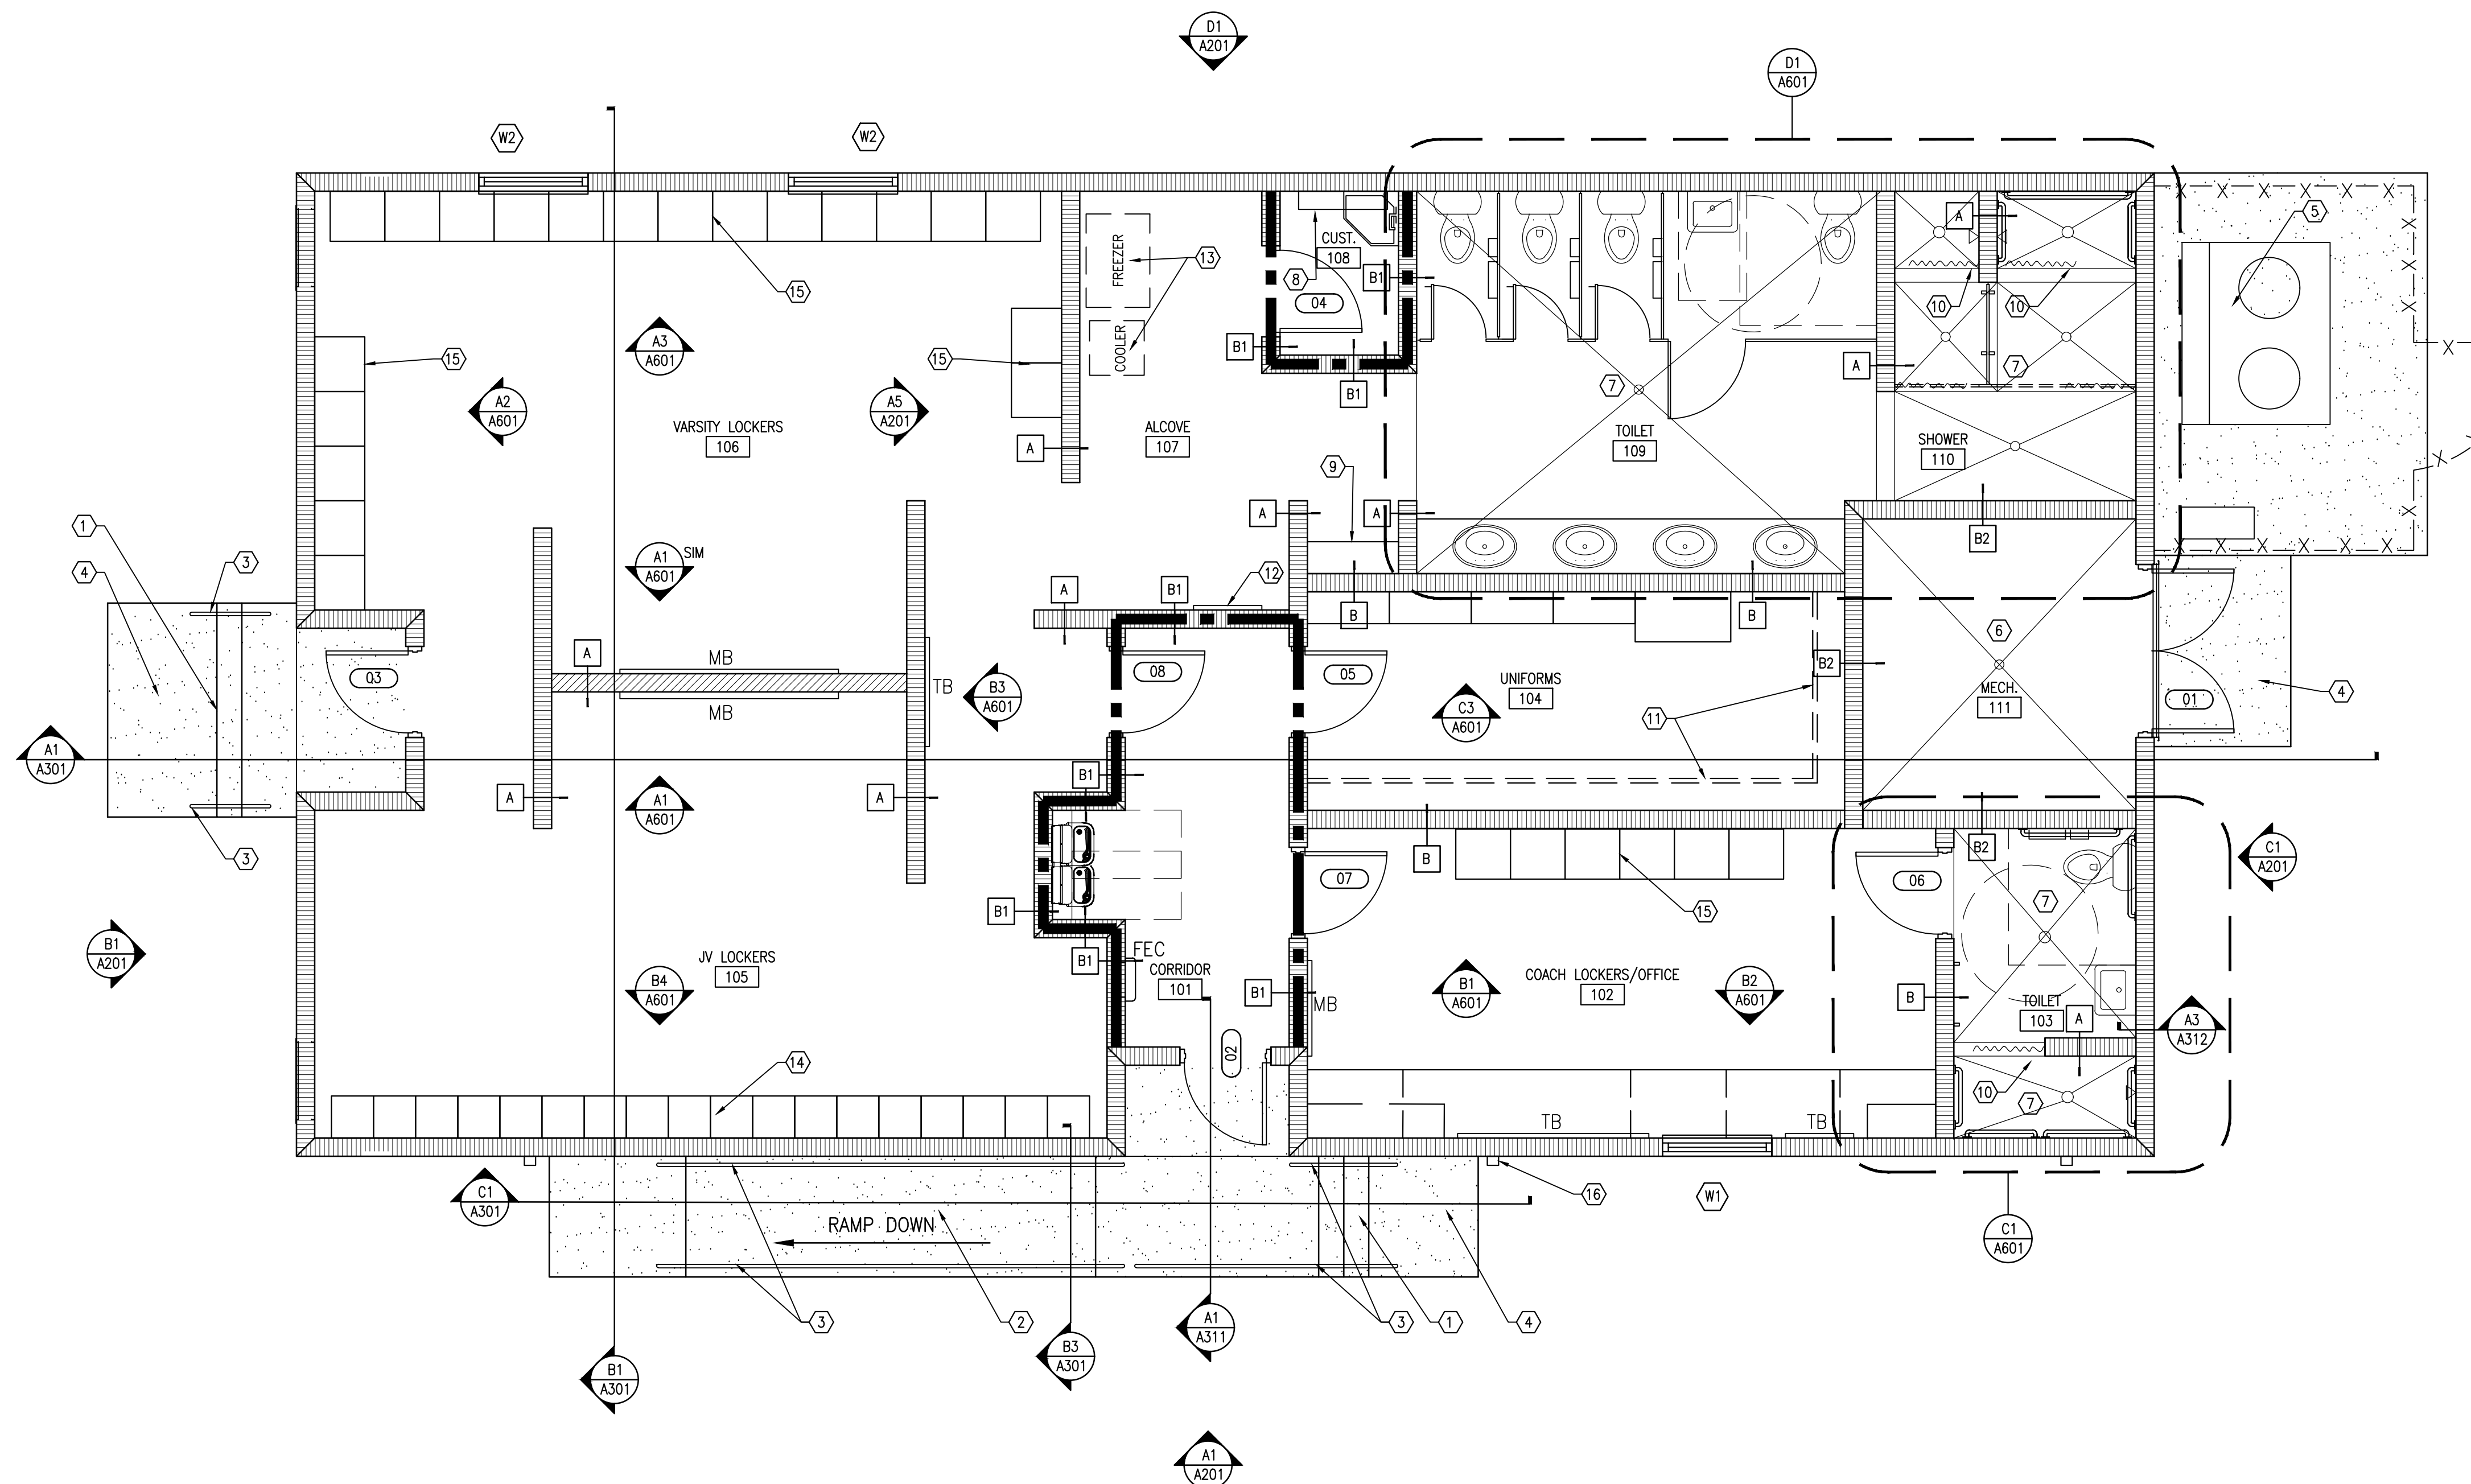


A1	FLOOR PLAN
----	------------


SCALE: 1/4"=1'-0"

NORTH




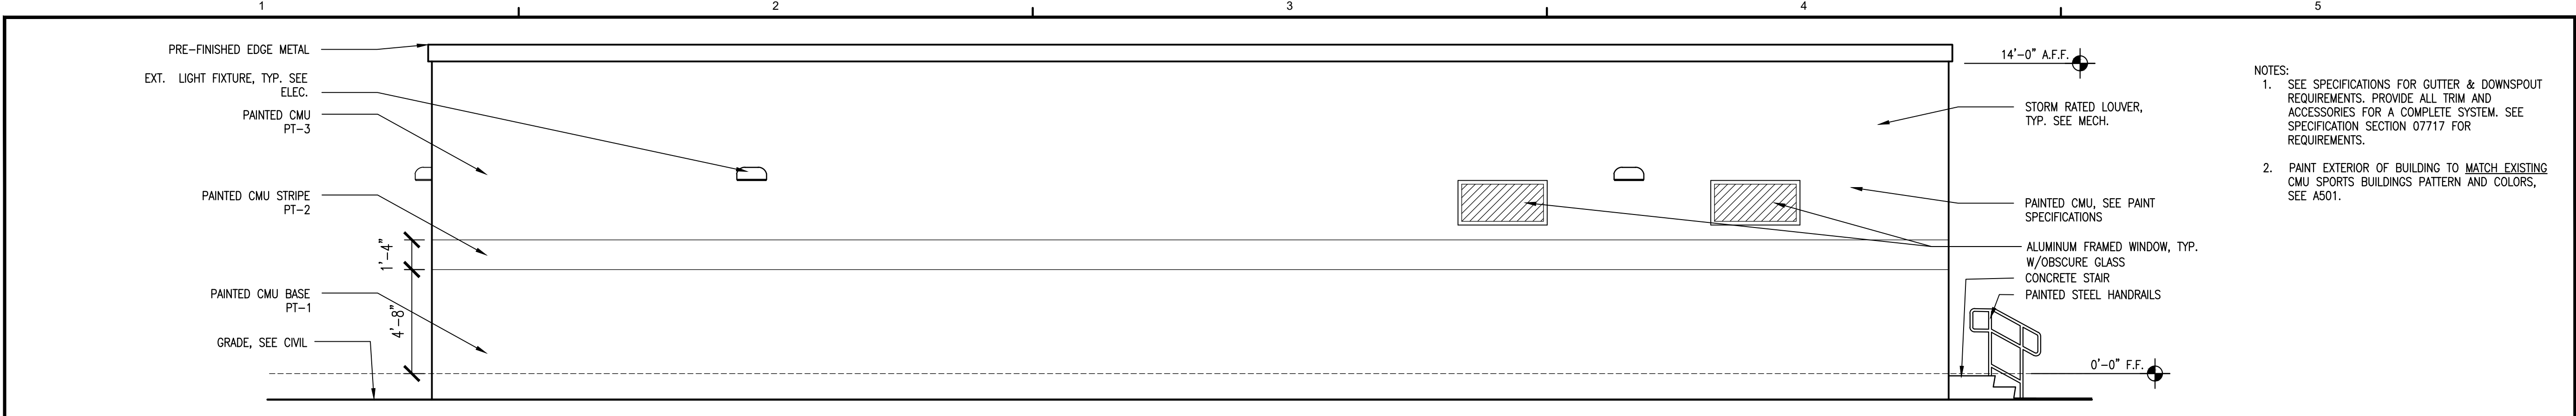


D1 NORTH ELEVATION
SCALE: 1/4"=1'-0"

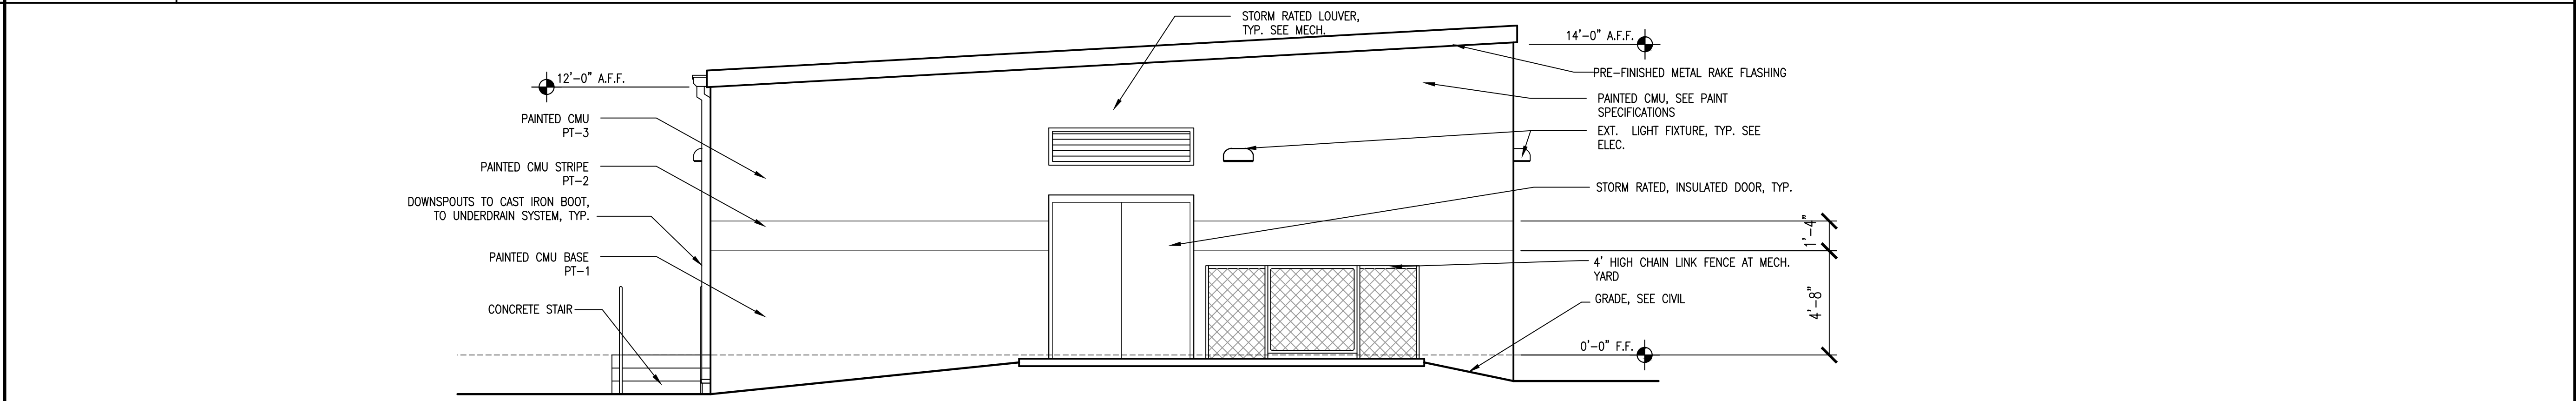

C1 EAST ELEVATION
SCALE: 1/4"=1'-0"

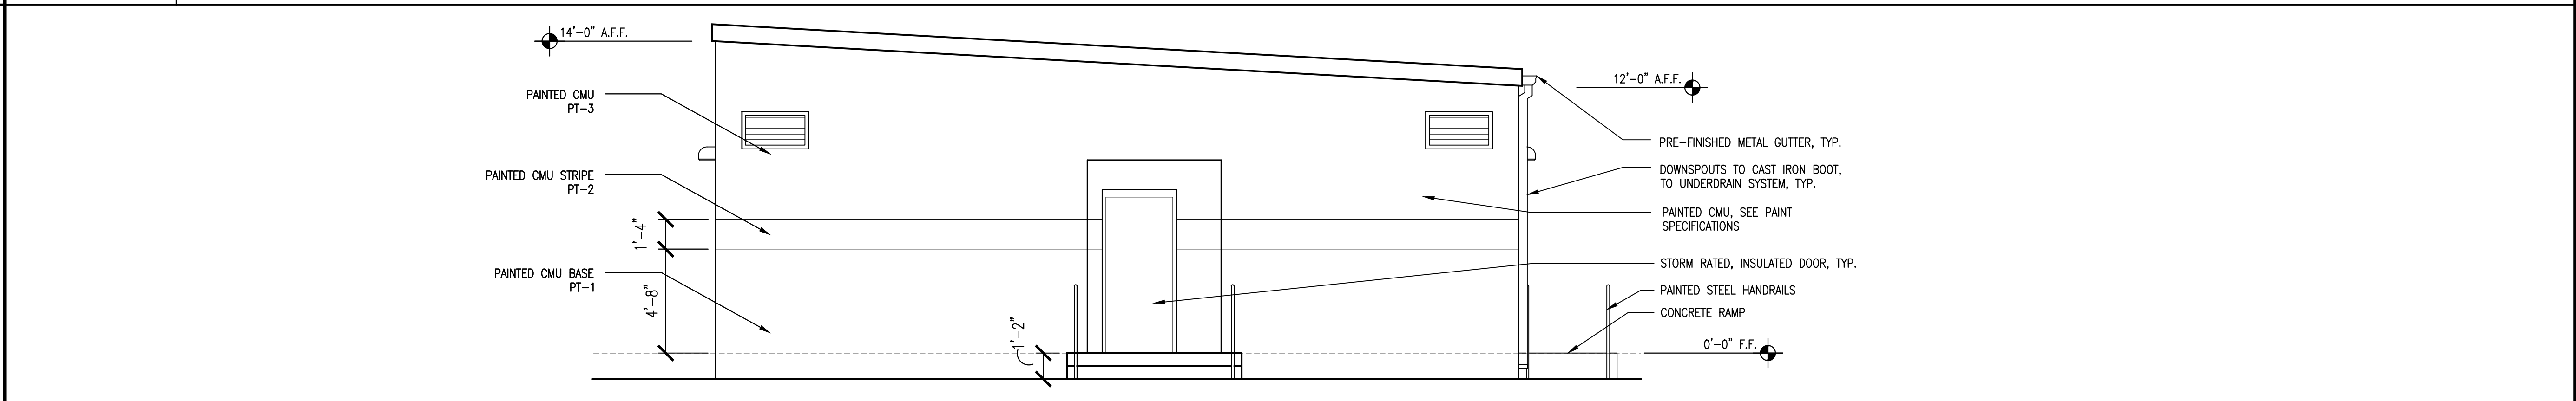

B1 WEST ELEVATION
SCALE: 1/4"=1'-0"

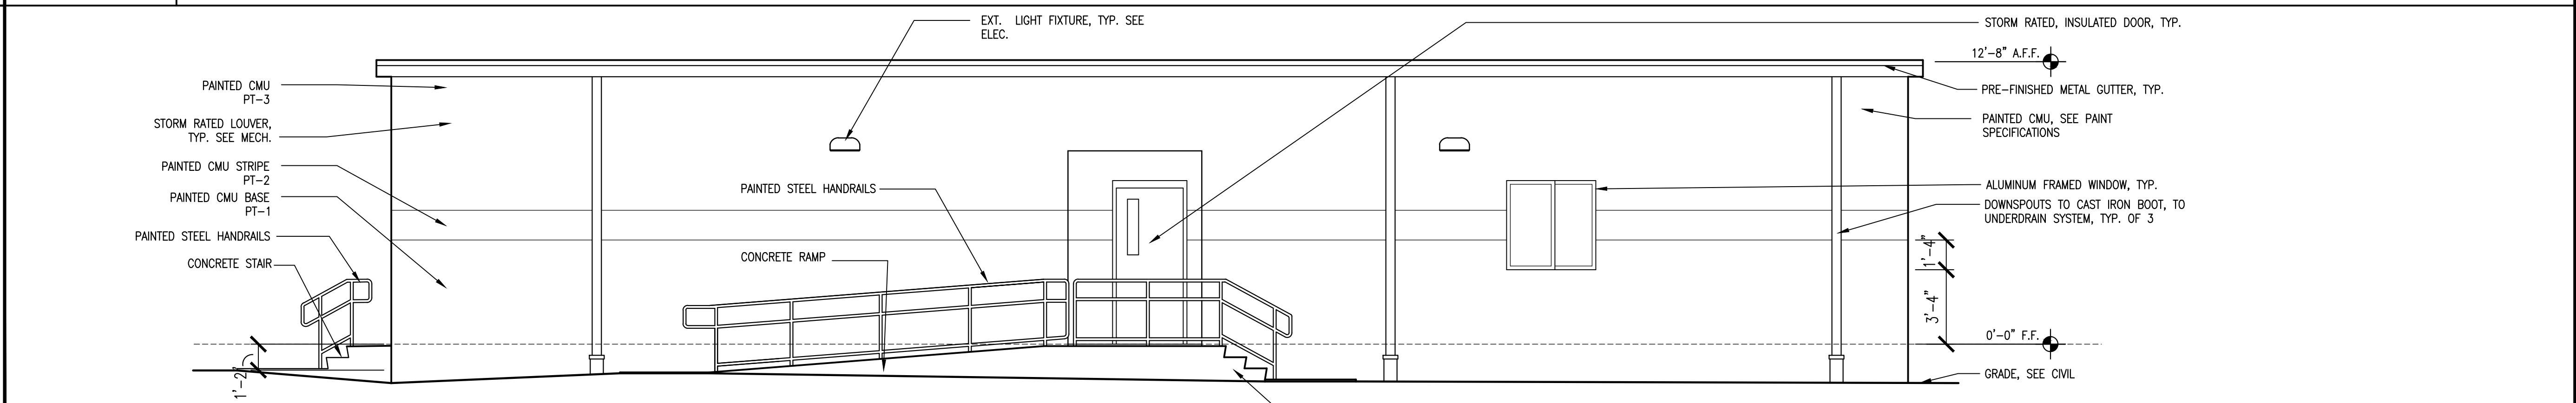

A1 SOUTH ELEVATION
SCALE: 1/4"=1'-0"

dag

DAG ARCHITECTS INC.
40 S. PALAFOX PLACE - STE 201
PENSACOLA, FL 32502
TELEPHONE: 850-429-9004 FAX: 850-429-9005
AA-C000745

OWNERSHIP OF INSTRUMENTS OF SERVICE
ALL REPORTS, PLANS, SPECIFICATIONS, COMPUTER FILES, FIELD DATA, NOTES AND OTHER DOCUMENTS AND INSTRUMENTS PREPARED BY THE CONSULTANT AS INSTRUMENTS OF SERVICE SHALL REMAIN THE PROPERTY OF THE CONSULTANT. THE CONSULTANT SHALL RETAIN ALL COMMON LAW, STATUTORY AND OTHER RESERVED RIGHTS, INCLUDING THE COPYRIGHT THEREON.

**PHASE III
DOCUMENTS**

**Pace High School
Softball Fieldhouse**
4065 Norris Rd.
Pace, FL 32571

Revision		
Date:	No.	Description:
-	-	-
-	-	-
Drawn By:
Checked By:

Date: 11-29-18

Project No.: 18045

Drawing Title:
EXTERIOR ELEVATIONS

Drawing No.: **A201**



DAG ARCHITECTS INC.
40 S. PALATKA PLACE - STE 201
PENSACOLA, FL 32502
TELEPHONE: 850-429-9004 FAX: 850-429-9005
AA-C000745

OWNERSHIP OF INSTRUMENTS OF SERVICE
ALL REPORTS, PLANS, SPECIFICATIONS, COMPUTER FILES, FIELD DATA,
NOTES AND OTHER DOCUMENTS AND INSTRUMENTS PREPARED BY
THE CONSULTANT AS INSTRUMENTS OF SERVICE SHALL REMAIN THE
PROPERTY OF THE CONSULTANT. THE CONSULTANT SHALL RETAIN ALL
COMMON LAW, STATUTORY AND OTHER RESERVED RIGHTS,
INCLUDING THE COPYRIGHT THEREON.

PHASE III
DOCUMENTS

Pace High School
Softball Fieldhouse
4065 Norris Rd.
Pace, FL 32571

Revision

Date:	No.	Description:

Drawn By: JML
Checked By: WJJ

Date: 11-29-18

Project No.: 18045

Drawing Title:
DOMESTIC
WATER PLAN


Drawing No.: P201

SHEET NOTES

1. ROUTE 3/4" CW AND 3/4" HW TO MIXING VALVE. MOUNT AT ±4'-0" AFF. INSTALL PER MANUFACTURER REQUIREMENTS.
2. ROUTE CW AND HW TO P-4 AND P-5 WITHIN WALL.
3. MECHANICAL EQUIPMENT SHOWN FOR COORDINATION ONLY.
4. PROVIDE ISOLATION VALVE IN THE VERTICAL RISE INSIDE MECHANICAL ROOM.
5. PROVIDE DRAIN PAN UNDER EWH-1

GENERAL NOTES

1. PROVIDE WATER HAMMER ARRESTERS ON HOT & COLD WATER SUPPLY BRANCHES SERVING SINGULAR, MULTIPLE OR GROUPS OF PLUMBING FIXTURES. ADHERENCE TO THE PLUMBING AND DRAINAGE INSTITUTE STANDARD P.D.I.-WH201 (PER SPECIFICATIONS) SHALL BE EMPLOYED IN DETERMINING PROPER SIZE, SELECTION, PLACEMENT, LOCATION AND INSTALLATION OF ARRESTERS.
2. PIPING ROUTED TO INDIVIDUAL FIXTURES SHALL BE FULL SIZE AS INDICATED ON PLUMBING FIXTURE SCHEDULE.

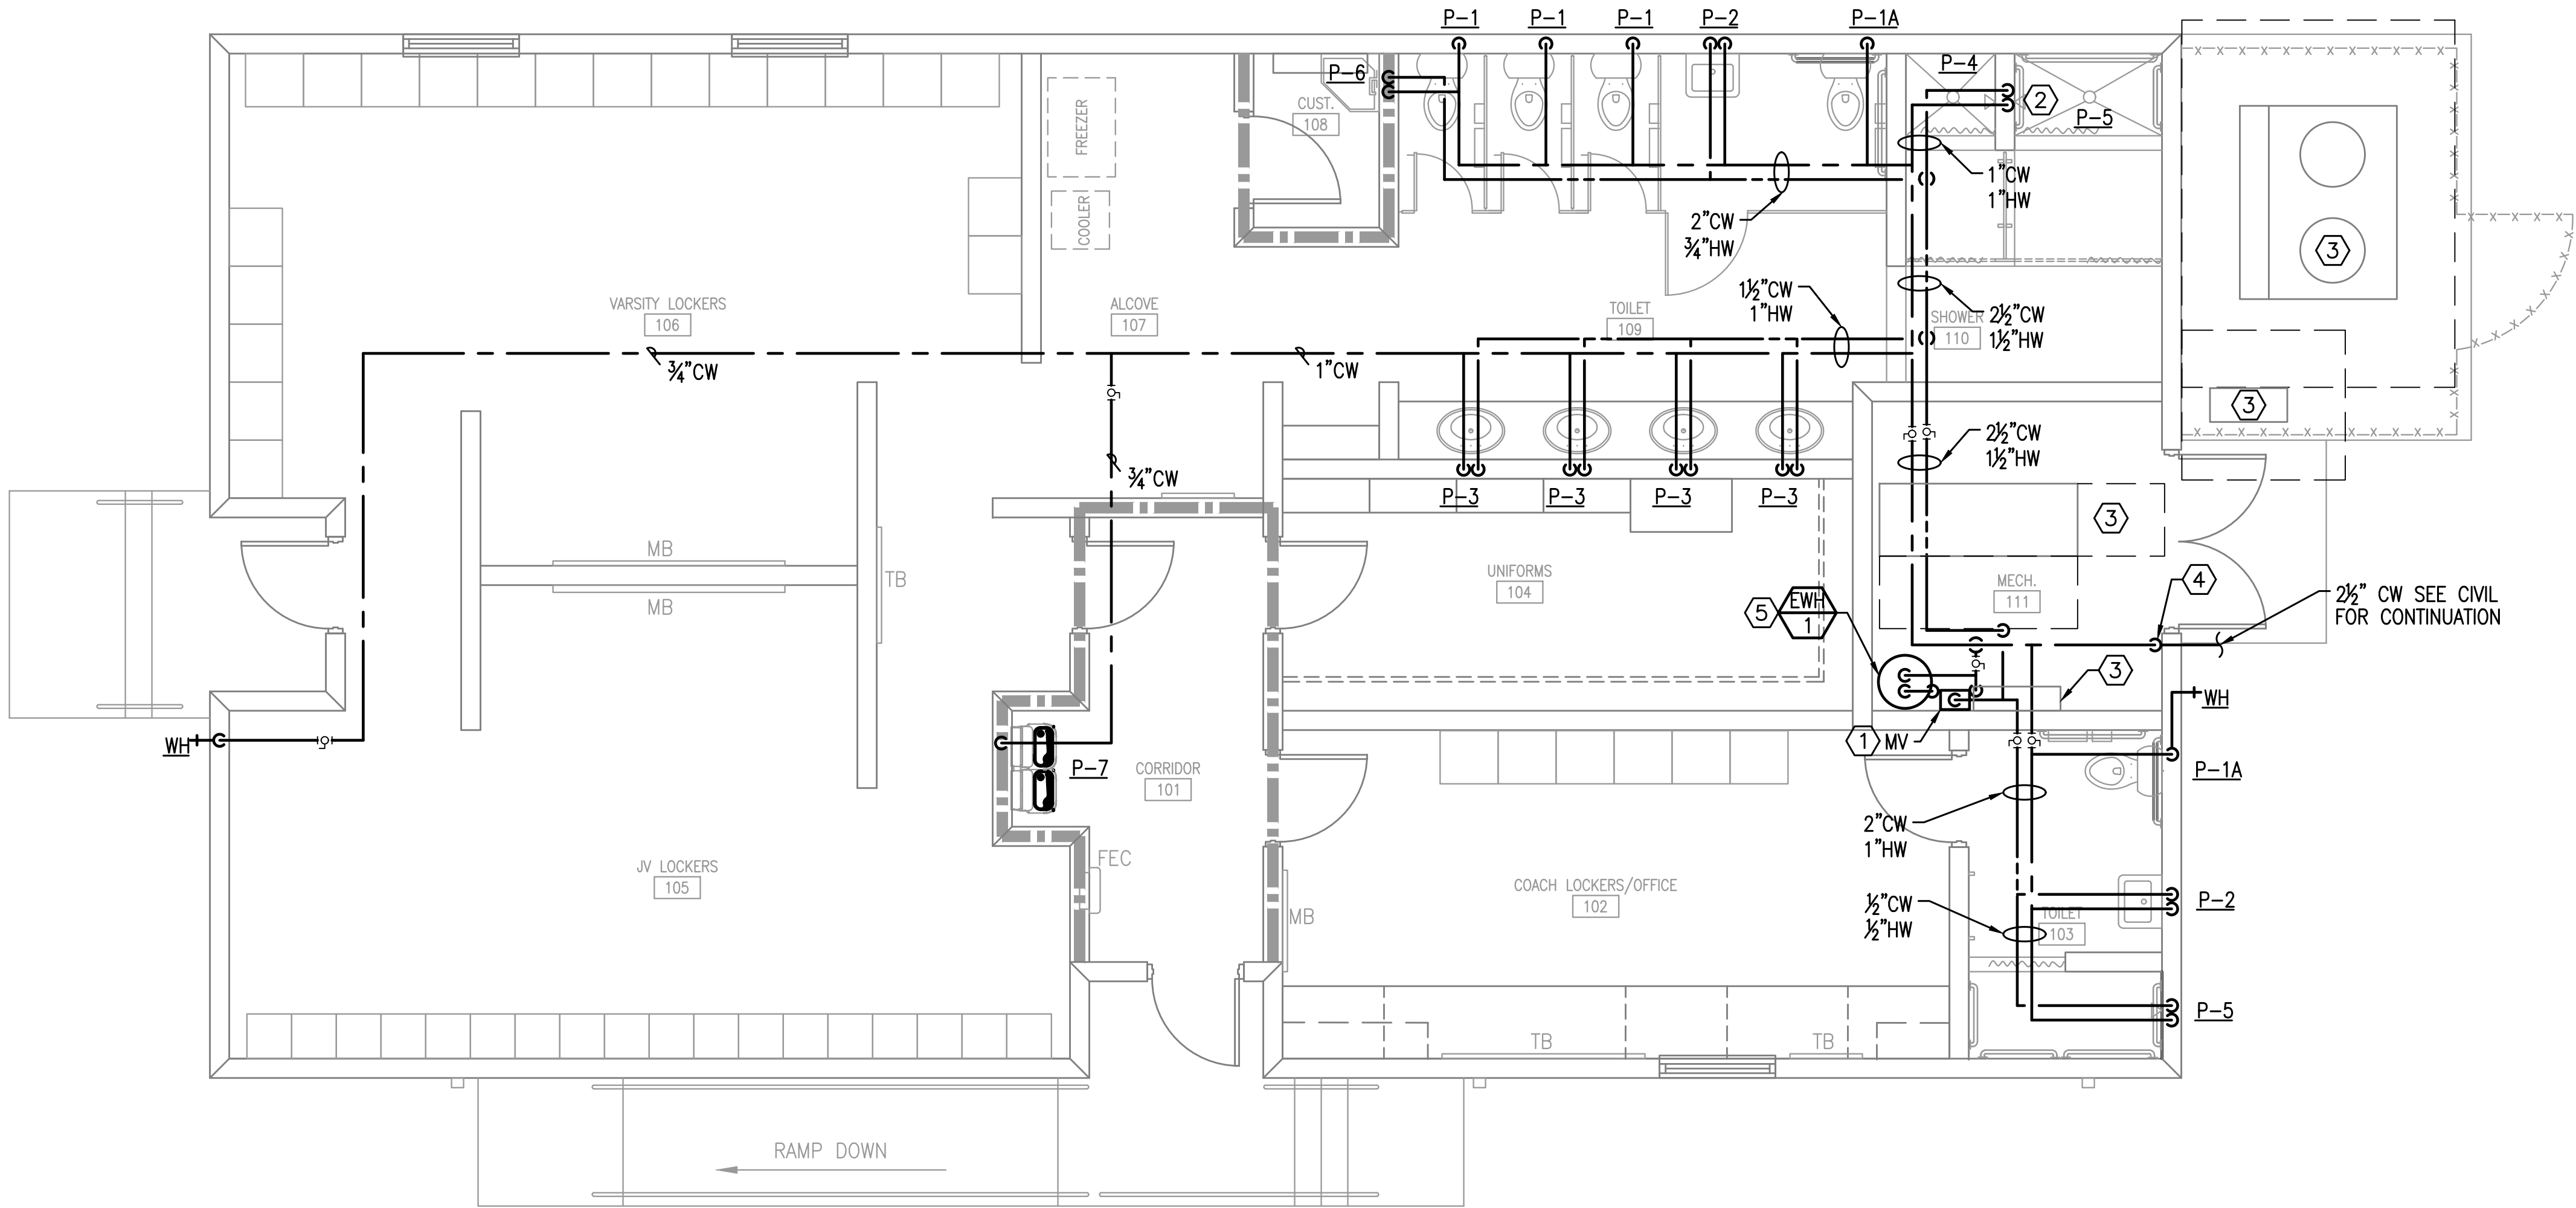

DOMESTIC WATER PLAN
SCALE: 1/4" = 1'-0"

Pace High School
Softball Fieldhouse
4065 Norris Rd.
Pace, FL 32571

Revision

Date:	No.	Description:

Drawn By: JML
Checked By: WJJ

Date: 11-29-18

Project No.: 18045

Drawing Title:
**MECHANICAL
NEW WORK**

Drawing No.: **M101**

SHEET NOTES

- 1 MOUNT UNIT ON 4" CONCRETE PAD.
- 2 EWH-1 SHOWN FOR COORDINATION.
- 3 ELECTRICAL SHOWN FOR COORDINATION.
- 4 ROUTE CONDENSATE TO FLOOR DRAIN SEE PLUMBING FOR FLOOR DRAIN LOCATIONS.
- 5 MOUNT LOUVER AT ±9'-4". COORDINATE LOUVER MOUNTING HEIGHT WITH ARCHITECT.
- 6 B.O.D. MANUFACTURERS CLEARANCE REQUIREMENTS.
- 7 LOCATION OF RED LIGHT INDICATING OAU FAILURE. REFER TO SEQUENCE ON M301.
- 8 LOCATION OF OAU/HP CONTROLLER. MOUNT AT ±4'-0" A.F.F. REFER TO SEQUENCE ON M301.
- 9 LOCATION OF TIME CLOCK. MOUNT AT ±4'-0" A.F.F. REFER TO SEQUENCE ON M301.

MECHANICAL NEW WORK
SCALE: 1/4"=1'-0"

ENLARGED MECHANICAL ROOM 112
SCALE: 1/2"=1'-0"

**Pace High School
Softball Fieldhouse**
4065 Norris Rd.
Pace, FL 32571

Revision

Date:	No.	Description:


Drawn By: SAM
Checked By: TAN

Date: 11-29-18

Project No.: 18045


Drawing Title:
**ELECTRICAL
LIGHTING PLAN**

Drawing No.: **E201**

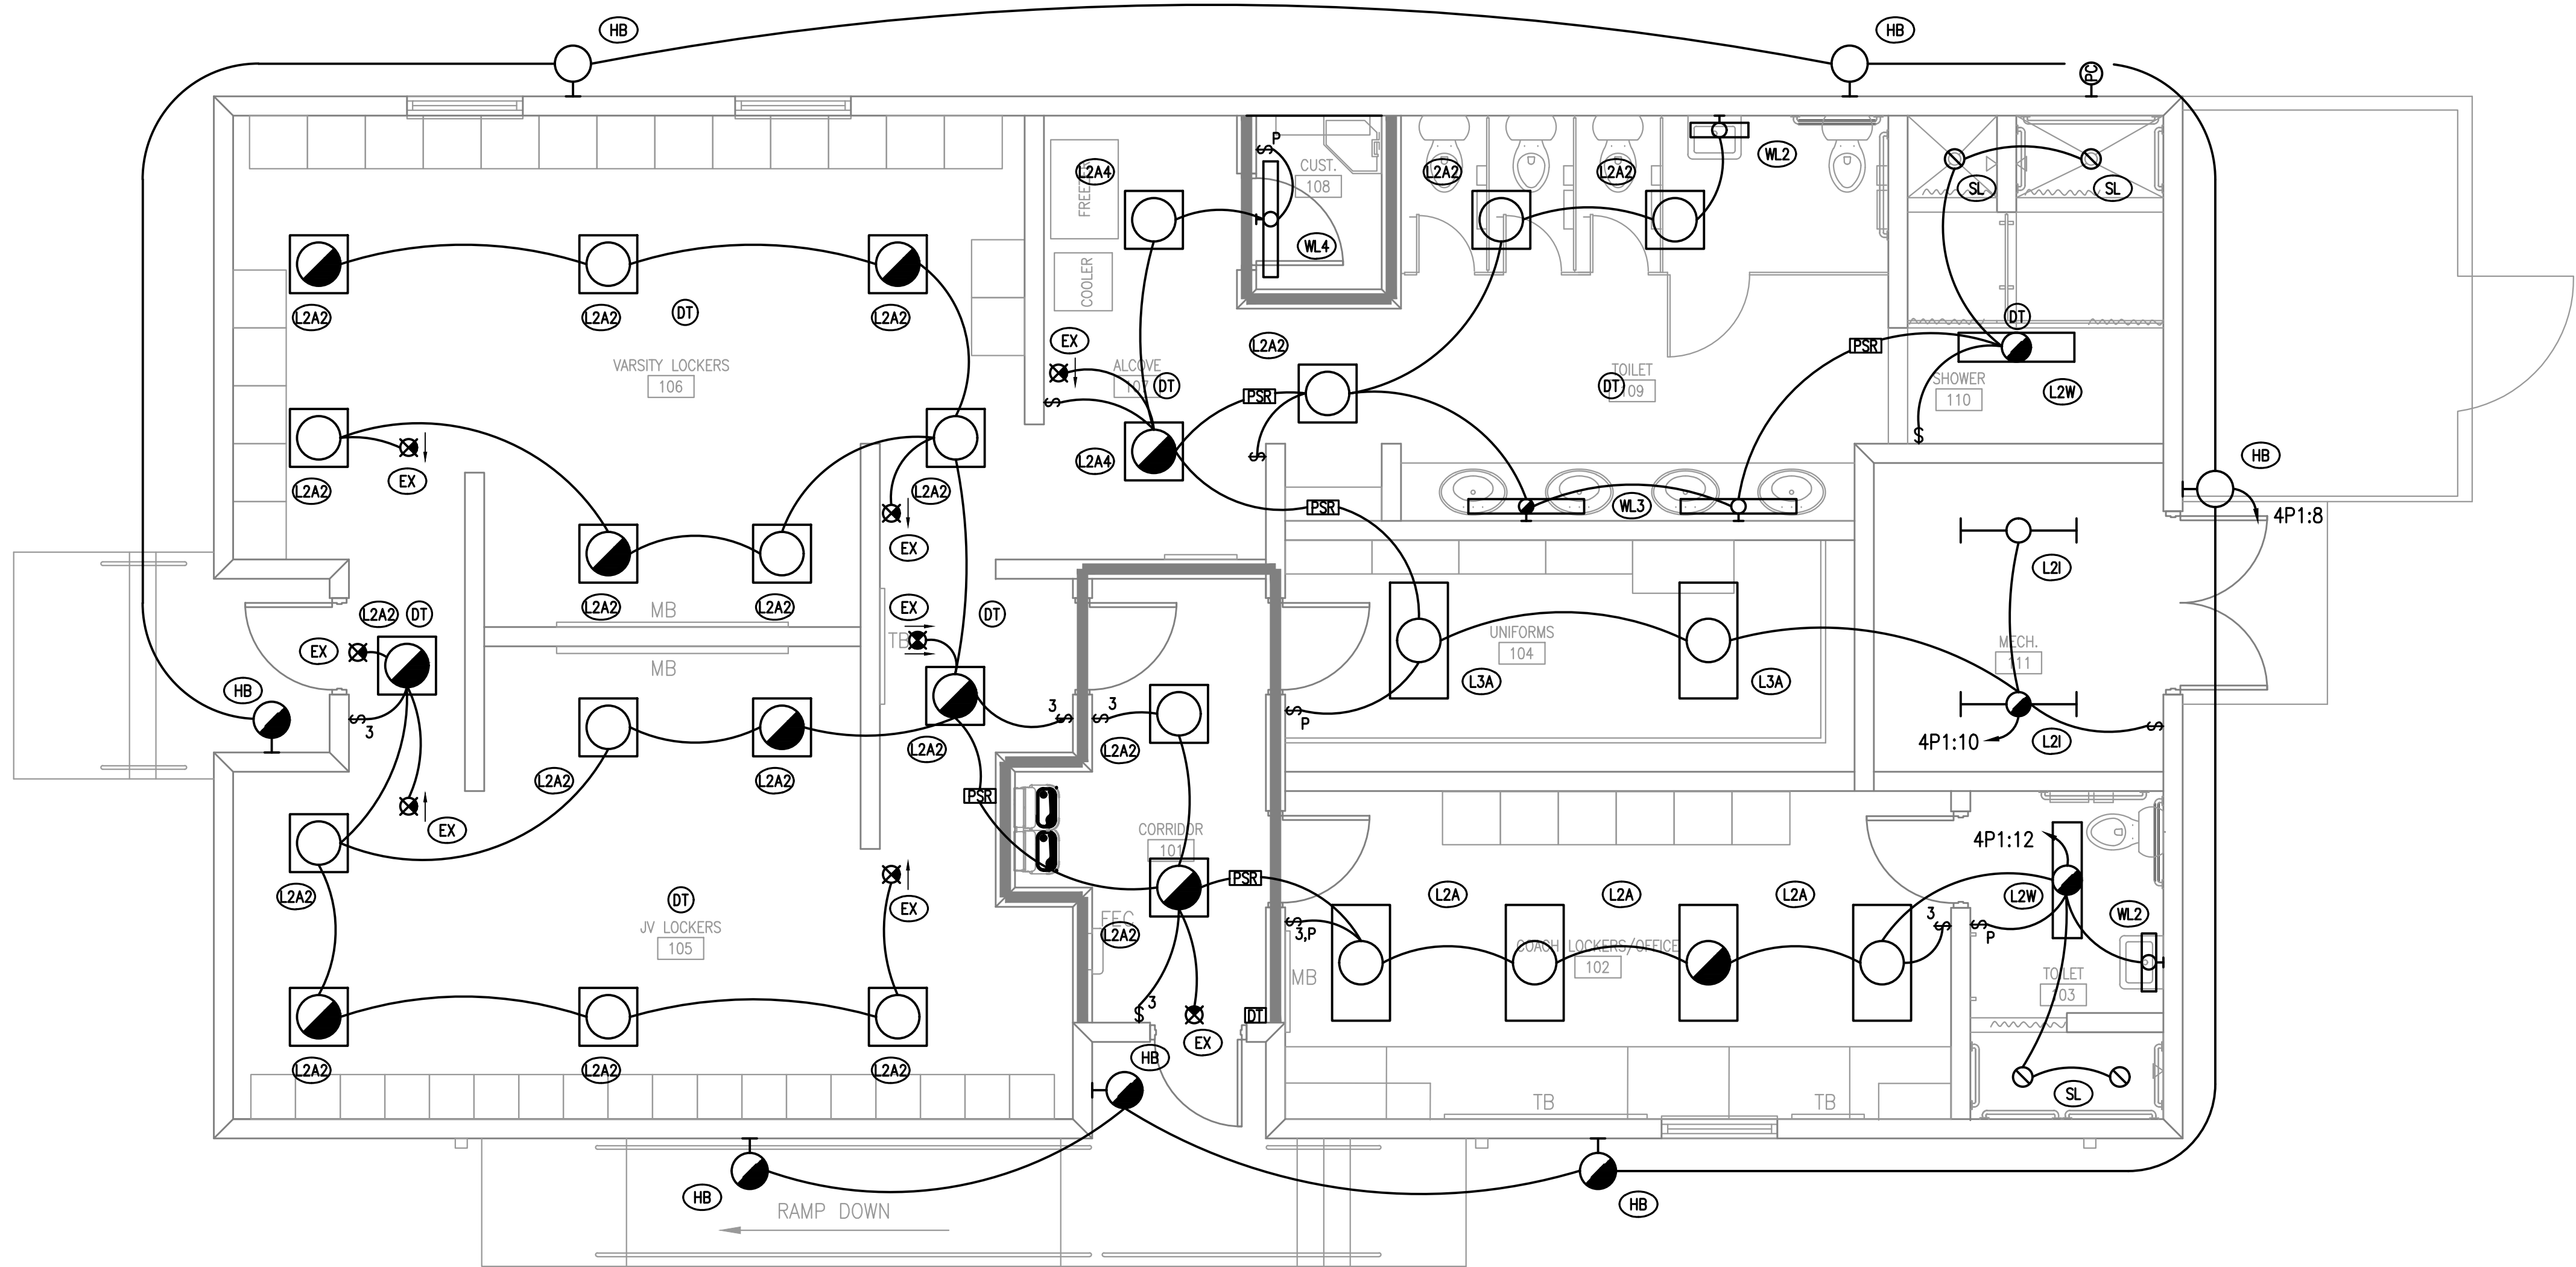

1 ELECTRICAL LIGHTING PLAN
4' 0' 4' 8'
SCALE: 1/4"=1'-0"

**Pace High School
Softball Fieldhouse**
4065 Norris Rd.
Pace, FL 32571

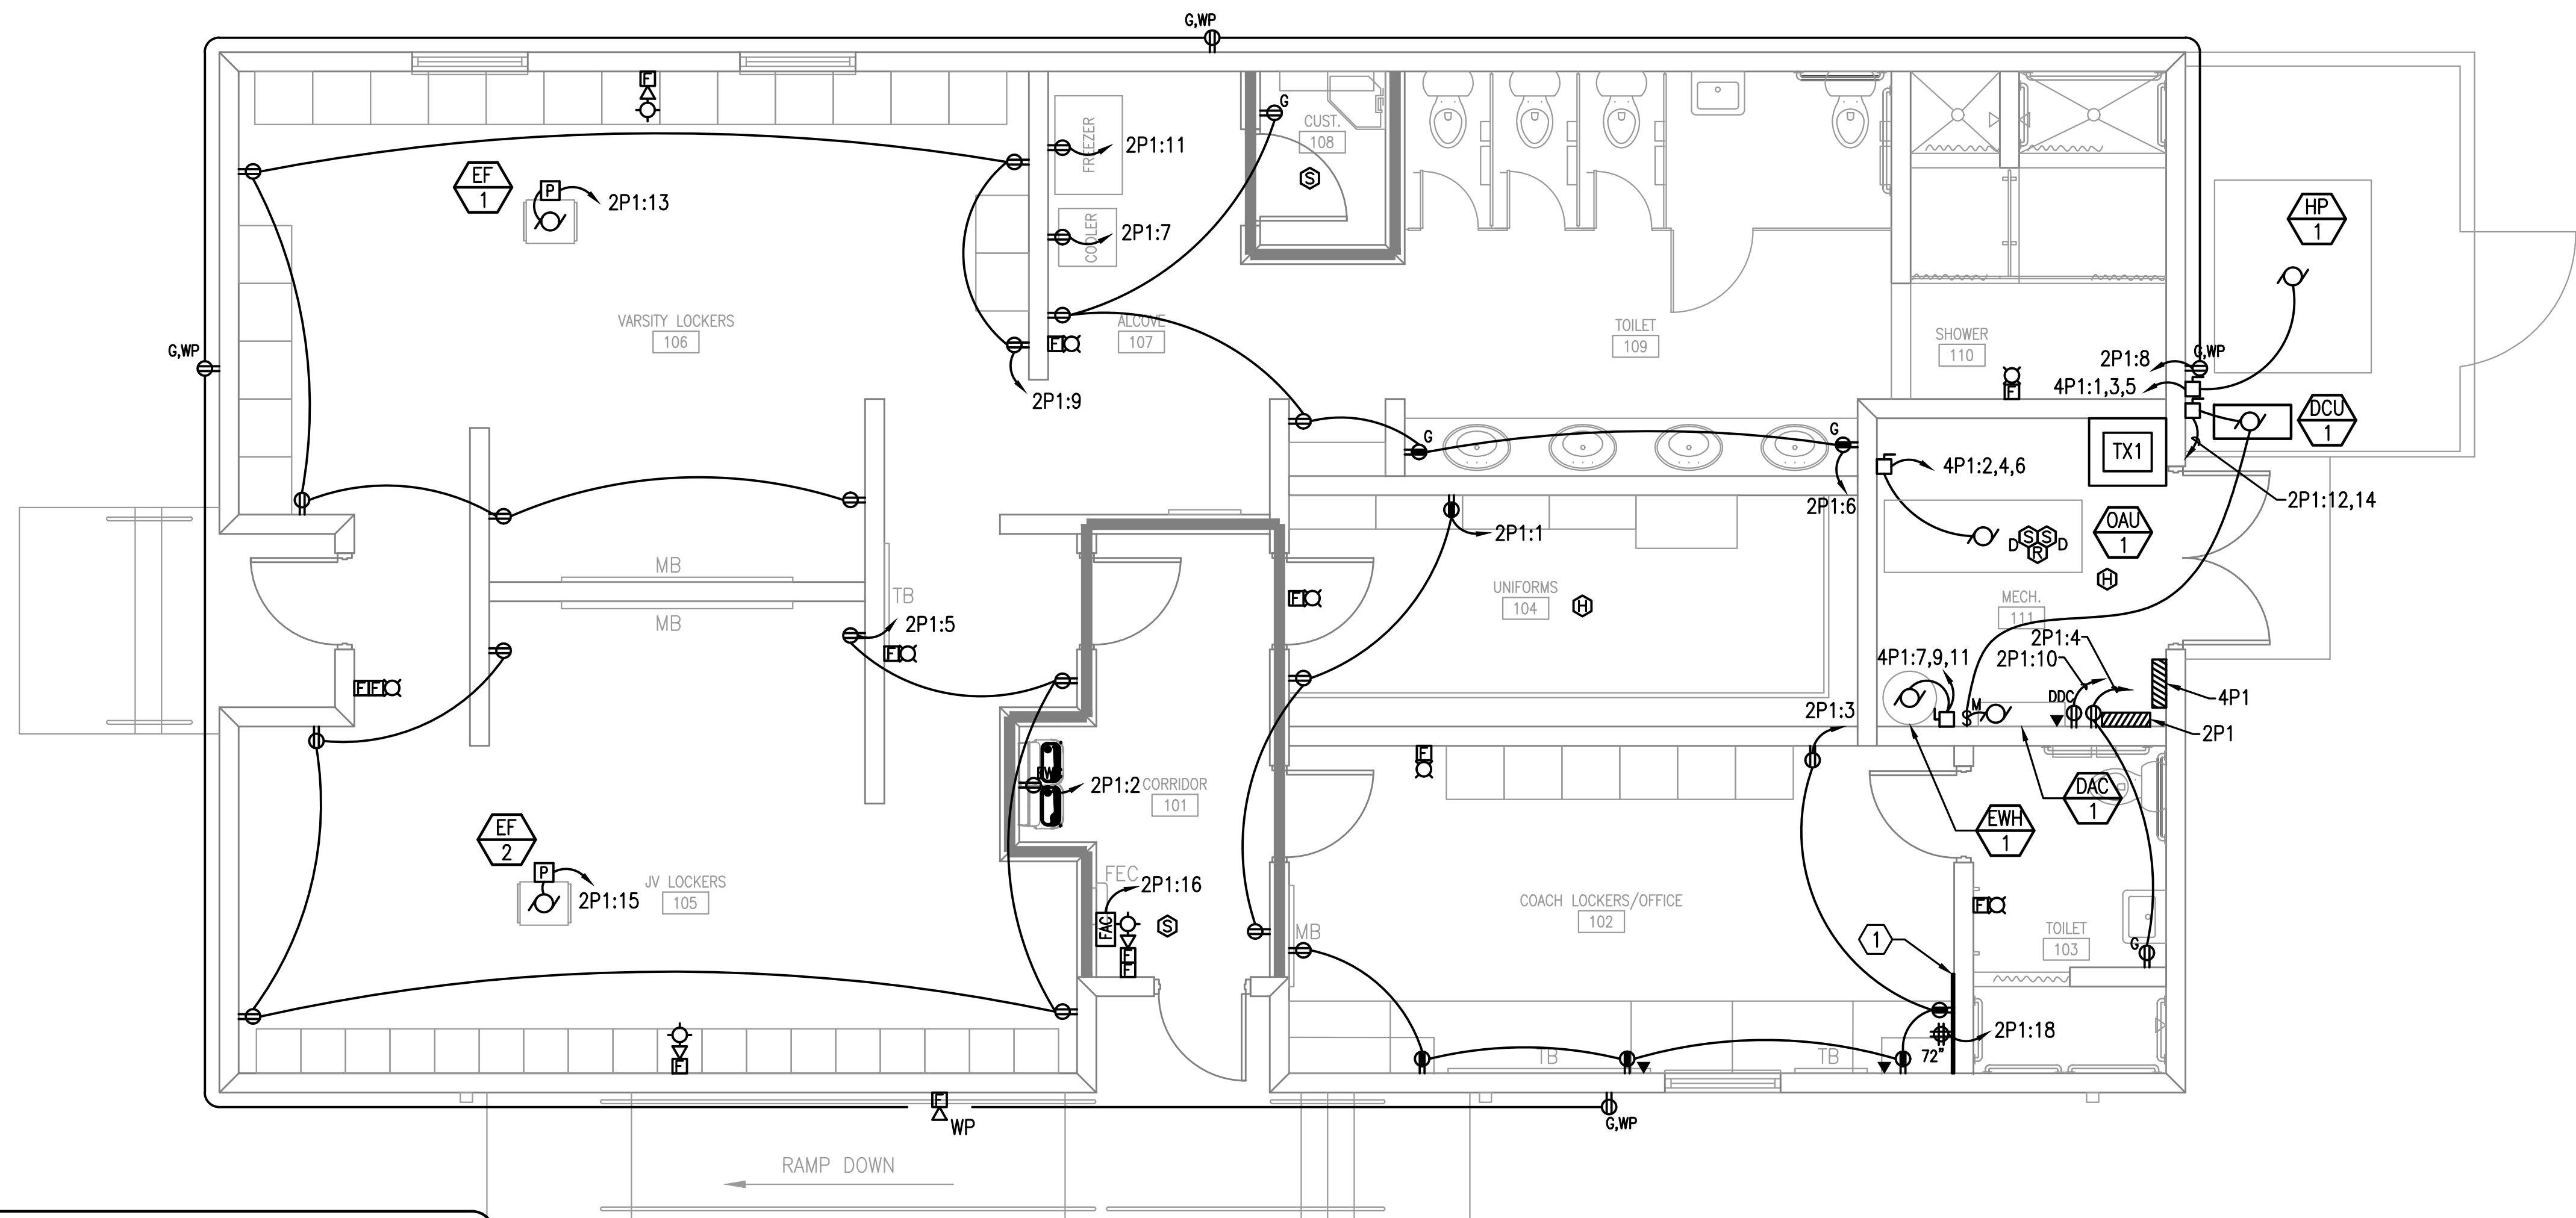

SHEET NOTES

- ① PLYWOOD BACKBOARD. ROUGH ALL ELECTRICAL OUTLETS IN BACKBOARD FOR FLUSH MOUNT INSTALLATION OF FACEPLATES. BACKBOARDS SHALL BE 3/4" THICK AB GRADE PLYWOOD. COUNTERSINK ALL SCREWS. PAINT ALL SURFACES PRIOR TO INSTALLATION WITH TWO COATS OF FIRE-RETARDANT PAINT, LIGHT GRAY IN COLOR. FINAL SURFACE SHALL BE UNIFORMLY SMOOTH AND EVEN. TOUCH UP AT END OF PROJECT. COORDINATE WORK WITH ELECTRICAL CONTRACTOR TO ENSURE THAT POWER RECEPTACLES ARE PROPERLY LOCATED AND WITH FACEPLATES FLUSH ON FACE OF BACKBOARD. TOP OF BACKBOARD SHALL BE MOUNTED AT 7'6" AFF AND BOTTOM OF BACKBOARD SHALL BE 6" AFF.

ELECTRICAL POWER PLAN
4' 0' 4' 8'
SCALE: 1/4"=1'-0"

Revision		
Date:	No.	Description:

Drawn By: SAM
Checked By: TAN

Date: 11-29-18

Project No.: 18045

Drawing Title:
**ELECTRICAL
POWER PLAN**

Drawing No.: E202